


EXISTING TO BE REMOVED


- 1 EXISTING GYP. BD. WALL TO BE REMOVED
- 2 EXISTING DOOR & FRAME TO BE REMOVED AND RELOCATED.
- 3 EXISTING WINDOW TO BE REMOVED AND RELOCATED.
- 4 ALL EXTERIOR EXISTING BULESTONE PAVERS TO BE REMOVED AND REUSED.
- 5 EXISTING MILLWORK TO BE REMOVED AND RELOCATED.
- 6 EXISTING BASE CABINETS AND COUNTERTOPS TO BE REMOVED AND RE-USED.
- 7 EXISTING PLUMBING FIXTURES TO BE REMOVED AND RE-USED.
- 8 EXISTING WALL FINISHES TO BE REMOVED THROUGHOUT SPACE.

- 9 EXISTING RADIATORS TO BE REMOVED THROUGHOUT
- 10 EXISTING LIGHT FIXTURES TO BE REMOVED AND RE-USED THROUGHOUT
- 11 EXISTING WALLS AND CEILINGS TO BE PATCHED AND REPAIRED THROUGHOUT

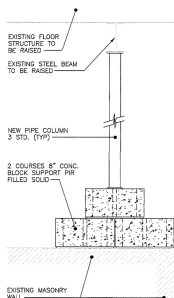


FRAMING DETAIL

SCALE: 1"=1'-0"

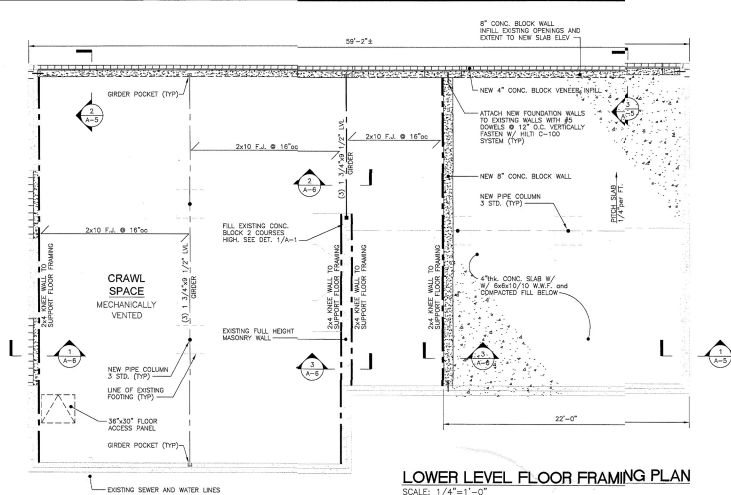

LOWER LEVEL FLOOR FRAMING PLAN

SCALE: 1/4"=1'-0"

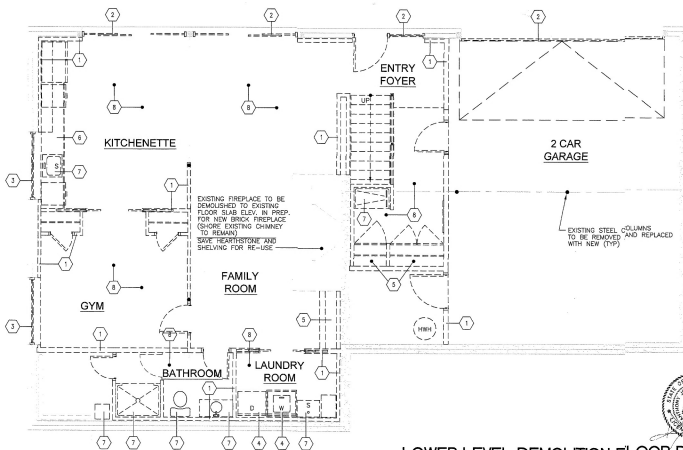

LOWER LEVEL DEMOLITION FLOOR PLAN

SCALE: 1/4"=1'-0"



PEQ.

No.	Date	Revision
-----	------	----------

**Mingolello
& Associates**
ARCHITECTS, LLC

90 Huntington Street
Shelton, CT 06484
203.925.1991 • Fax: 203.925.8263
Email: mh.arch@snet.net

Project Title
**RENOVATIONS
TO
HOLLY
RESIDENCE**

51 BEECHDALE ROAD
DOBBS FERRY, NY

Date 11-18-21	Dwn/Chkd KF/AJM
Scale AS SHOWN	Proj. No. 4020


Drawing Title
**DEMOLITION
FLOOR PLANS**

RECEIVED

NIV 3.9.2021


VILLAGE OF DOBBS FERRY
BUILDING DEPARTMENT

~~A-~~

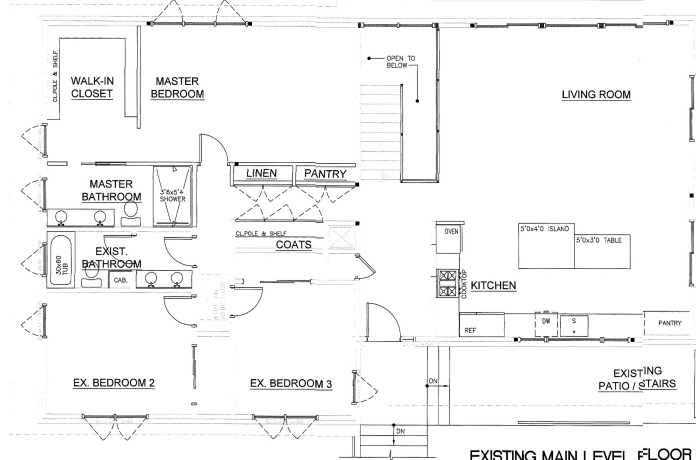


EXISTING MAIN LEVEL FLOOR PLAN

SCALE: 1/4"=1'-0"

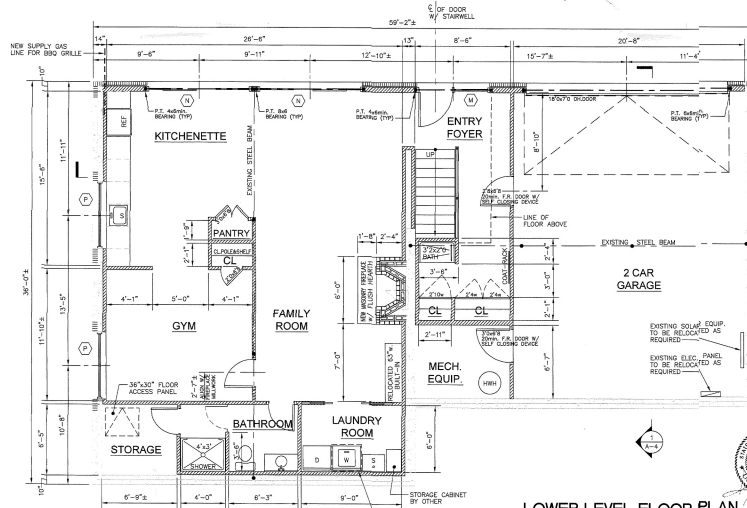

LOWER LEVEL FLOOR PLAN

 SCALE: 1/4"=1'-0"



No.	Date	Revision
-----	------	----------

Mingolello & Associates
ARCHITECTS, LLC

10 Harrington Street
Shelton, CT 06484
203.325.1391 • Fax: 203.325.6263
Email: mca@mingolello.com

Project Title
**RENOVATIONS
TO
HOLLY
RESIDENCE**

51 BEECHDALE ROAD
DOVER, CT 06430

Date: 11-18-21 DW/2024
Scale: AS SHOWN Proj. No. 40220


Drawing Title
FLOOR PLANS



A-2

of

This drawing and details on it, as an instrument of service, is the property of Mingoello & Associates, LLC. It shall not be used for any other project or purpose without the written consent of the architect.

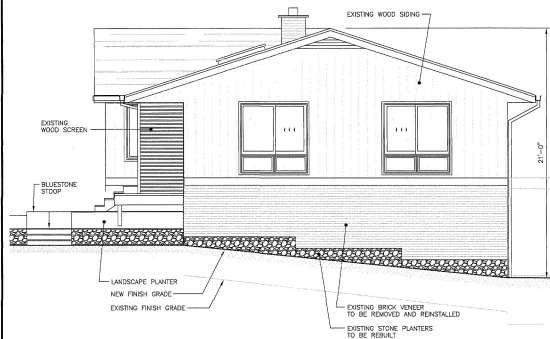

RIGHT SIDE ELEVATION

SCALE: 1/4"=1'-0"



REAR ELEVATION


SCALE: 1/4"=1'-0"

GENERAL NOTES

EXTERIOR FINISH SCHEDULE: MATCH / REUSE EXISTING


- EXISTING REUSE RED/ORANGE BRICK
- EXISTING PAINTED WOOD SIDING, BM 1631--MIDNIGHT OIL
- EXISTING REUSE FIELDSTONE RETAINING WALLS
- EXISTING NATURAL CEDAR SCREENS, DOORS AND GARAGE DOORS
- EXISTING BLACK ALUMINUM BOX GUTTERS
- EXISTING REUSE LIGHT FIXTURES, WINDOWS AND DOORS

ALL LIGHTING SHALL COMPLY WITH SECTION 300-41

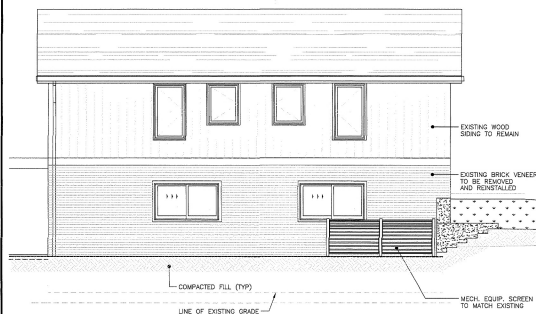

LEFT SIDE ELEVATION

SCALE: 1/4"=1'-0"

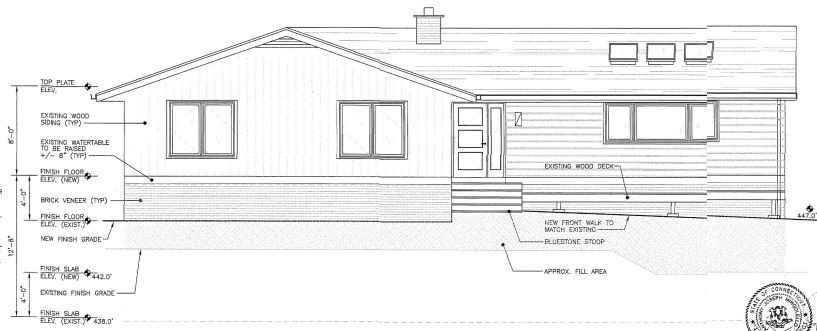

FRONT ELEVATION

SCALE: 1/4"=1'-0"

No. Date Revision

Mingoello & Associates
ARCHITECTS, LLC

60 Huntington Street
Shelton, CT 06484
203.923.9191 • Fax: 203.923.6253
Email: mingoello@mac.com

Project Title
**RENOVATIONS
TO
HOLLY
RESIDENCE**

61 BEECHDALE ROAD
DOBBS FERRY, NY

Date: 11-18-21 Des./Check: K7/AJM
Scale: AS SHOWN Proj. No.: 4000


Drawing Title
ELEVATIONS




A-3

of


This drawing and details on it, as an instrument of service, is the property of the architect and may be used for this specific project and shall not be copied, copied or reproduced without consent of the architect.

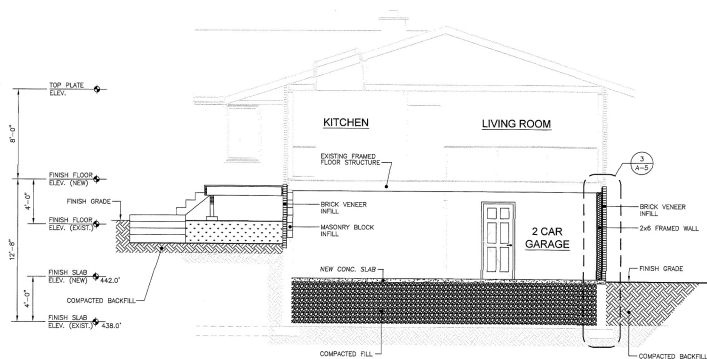

1 BUILDING SECTION
SCALE: 1/4"=1'-0"

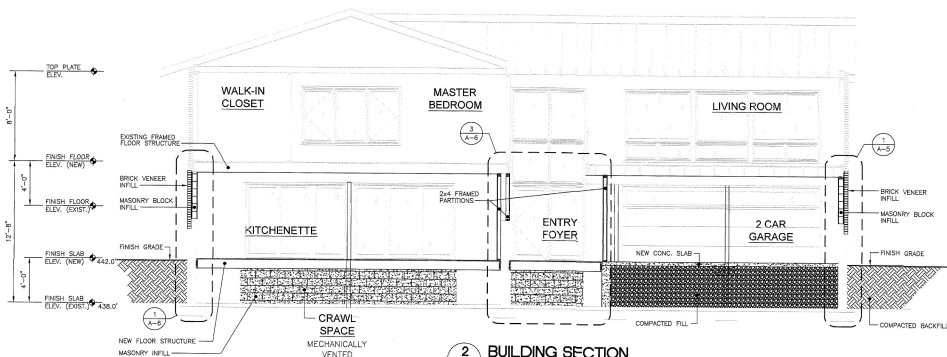

2 BUILDING SECTION
SCALE: 1/4"=1'-0"

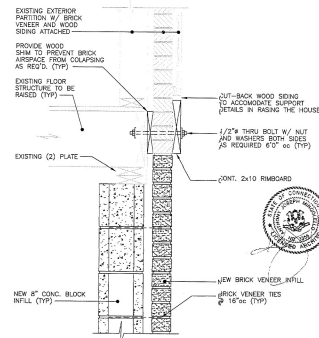

3 TYPICAL BRICK REINFORCING DETAIL
SCALE: 1 1/2"=1'-0"

No. Date Revision

Mingolello & Associates
ARCHITECTS, LLC

90 Huntington Street
Bristol, CT 06010
203.925.1991 • Fax: 203.925.5263
Email: mh.arts@mac.com

Project Title
**RENOVATIONS
TO
HOLLY
RESIDENCE**

51 BEECHDALE ROAD
DOBB'S FERRY, NY


Date: 11-18-21
Drawn: JLM
Scale: 1/4"=1'-0"
Pkg. No.: 4020

Drawing Title
ELEVATIONS

A-4

of

A-5

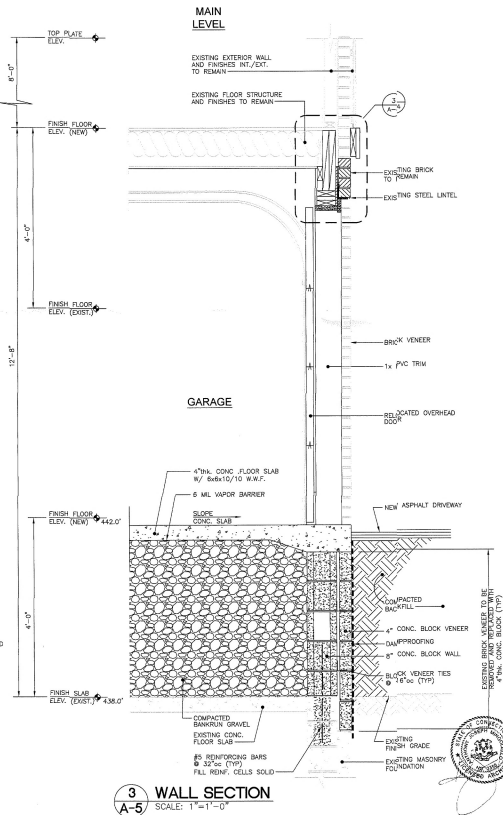

A-6

