

LEGEND

EXISTING TO REMAIN
NEW GYP. BD. PARTITION

FIRE PROTECTION NOTE:

GENERAL CONTRACTOR WILL SUBMIT A CERTIFIED FIRE SPRINKLER PLAN, INCLUDING BACKFLOW DESIGN AND FIRE ALARM PLAN DESIGNED IN ACCORDANCE WITH 'DOBBS FERRY BUILDING CODE'

ROOM FINISH SCHEDULE


NAME	FLOOR	BASE	N.WALL	S.WALL	E.WALL	W.WALL	CEILINGS	REMARKS
MAT	FIN	MAT	FIN	MAT	FIN	MAT	FIN	
MAIN LEVEL FLOOR PLAN								
WALK-IN CLOSET	EX. WOOD	CLEAR SEALER	WOOD	PTD.	GYP. BD.	PTD.	GYP. BD.	FLOORING NOTE: PATCH AND REPAIR WHERE REQUIRED
MASTER BEDROOM	EX. WOOD	CLEAR SEALER	WOOD	PTD.	GYP. BD.	PTD.	GYP. BD.	FLOORING NOTE: PATCH AND REPAIR WHERE REQUIRED
MASTER BATHROOM	CER. TILE	—	CER. TILE	—	GYP. BD.	CER. TILE	GYP. BD.	
EXISTING BATHROOM	CER. TILE	—	CER. TILE	—	GYP. BD.	CER. TILE	GYP. BD.	
EX. BEDROOM 2	EX. WOOD	CLEAR SEALER	WOOD	PTD.	EX. PTD.	EX. PTD.	EX. PTD.	FLOORING NOTE: PATCH AND REPAIR WHERE REQUIRED
EX. BEDROOM 3	EX. WOOD	CLEAR SEALER	WOOD	PTD.	EX. PTD.	EX. PTD.	EX. PTD.	FLOORING NOTE: PATCH AND REPAIR WHERE REQUIRED
HALLWAY	EX. WOOD	CLEAR SEALER	WOOD	PTD.	EX. PTD.	EX. PTD.	EX. PTD.	FLOORING NOTE: PATCH AND REPAIR WHERE REQUIRED
KITCHEN	NEW WOOD	CLEAR SEALER	WOOD	PTD.	GYP. BD.	PTD.	GYP. BD.	
LIVING ROOM	NEW WOOD	CLEAR SEALER	WOOD	PTD.	GYP. BD.	PTD.	GYP. BD.	
LOWER LEVEL FLOOR PLAN								
FAMILY ROOM	EX. CONC.	CLEAR SEALER	WOOD	PTD.	THIN BRICK	—	WOOD STAINED	FLOORING ALTERNATE RADIANT HEAT W/ STONE TILE
KITCHENETTE	EX. CONC.	CLEAR SEALER	WOOD	PTD.	THIN BRICK	—	WOOD STAINED	FLOORING ALTERNATE RADIANT HEAT W/ STONE TILE
BEDROOM	EX. CONC.	CLEAR SEALER	WOOD	PTD.	GYP. BD.	PTD.	GYP. BD.	FLOORING ALTERNATE RADIANT HEAT W/ STONE TILE
BATHROOM	CER. TILE	—	WOOD	PTD.	GYP. BD.	PTD.	GYP. BD.	
LAUNDRY ROOM	CER. TILE	—	WOOD	PTD.	GYP. BD.	PTD.	GYP. BD.	
ENTRY FOYER	EX. CONC.	CLEAR SEALER	WOOD	PTD.	THIN BRICK	—	GYP. BD.	FLOORING ALTERNATE RADIANT HEAT W/ STONE TILE
MECH. EQUIP. ROOM	EX. CONC.	—	—	—	GYP. BD.	PTD.	GYP. BD.	ALL WOOD FRAMED WALLS AN CEILING TO RECEIVE 5/8" F.C. GYP. BD.
GARAGE	EX. CONC.	—	—	—	GYP. BD.	PTD.	GYP. BD.	ALL WOOD FRAMED WALLS AN CEILING TO RECEIVE 5/8" F.C. GYP. BD.

DOOR / WINDOW SCHEDULE

SYM	RGH/MSNRY	OPN.	TYPE	MANUFACTURER & CAT#	GLAZING	QNT	REMARKS
W.	H.						
A	10'-0"	3'-6"	COMBO		LOW 'E' INSULATED		GLIDER/FIXED/GLIDER
B							
C	5'-10"	6'-2"	COMBO		LOW 'E' INSULATED		GLIDER over FIXED
D							
E	16'-8"	6'-2"	COMBO		LOW 'E' INSULATED		GLIDER/FIXED/GLIDER over FIXED/FIXED/FIXED
F							
G	6'-6"	8'-5"	COMBO		LOW 'E' INSULATED		FIXED/FIXED over FIXED/FIXED
H							
J	2'-10"	4'-10 1/2"	CSMNT		LOW 'E' INSULATED		
K	2'-10"	3'-6"	CSMNT		LOW 'E' INSULATED		TEMPERED GLASS AT K1
K1							
L	5'-10"	4'-10 1/2"	CSMNT		LOW 'E' INSULATED		
M	6'-0"	6'-9 3/4"			LOW 'E' INSULATED		INSWING GLASS DOOR W/ SIDELIGHT
N	9'-0"	6'-9 3/4"			LOW 'E' INSULATED		SLIDING TRIPLE DOOR
P	6'-0"	3'-6"	GLIDER		CLEAR INSULATED		
Q	9'-0"	5'-0"	COMBO		LOW 'E' INSULATED		CSMNT/FIXED/CSMNT
R	9'-0"	4'-2"	SKY LIGHT		LOW 'E' INSULATED		TRIPLE UNIT W/ 10"W. DIVISIONS
S							FRONT ENTRY DOOR W/ SIDELIGHT


WINDOW AND DOOR NOTES:

- JAMBS TO BE 6 9/16" (CONTRACTOR TO VERIFY ALL WALL THICKNESSES PRIOR TO ORDERING)
- PROVIDE WINDOW OPENING DEVICES AN ALL WINDOWS W/ SILLS LESS THAN 24" AFF
- ALL WINDOWS AND DOORS TO HAVE MIN. 0.32 'U' VALUE.
- ALL OPERABLE SASHES TO HAVE INSECT SCREENS.
- ALL WINDOW AND DOOR UNIT EXTERIORS TO BE ALUMINUM CLAD, COLOR: WHITE.
- ALL WINDOW AND DOOR UNIT INTERIORS TO BE FINISHED WHITE.
- SEE ELEVATIONS FOR DOOR AND WINDOW HINGING.

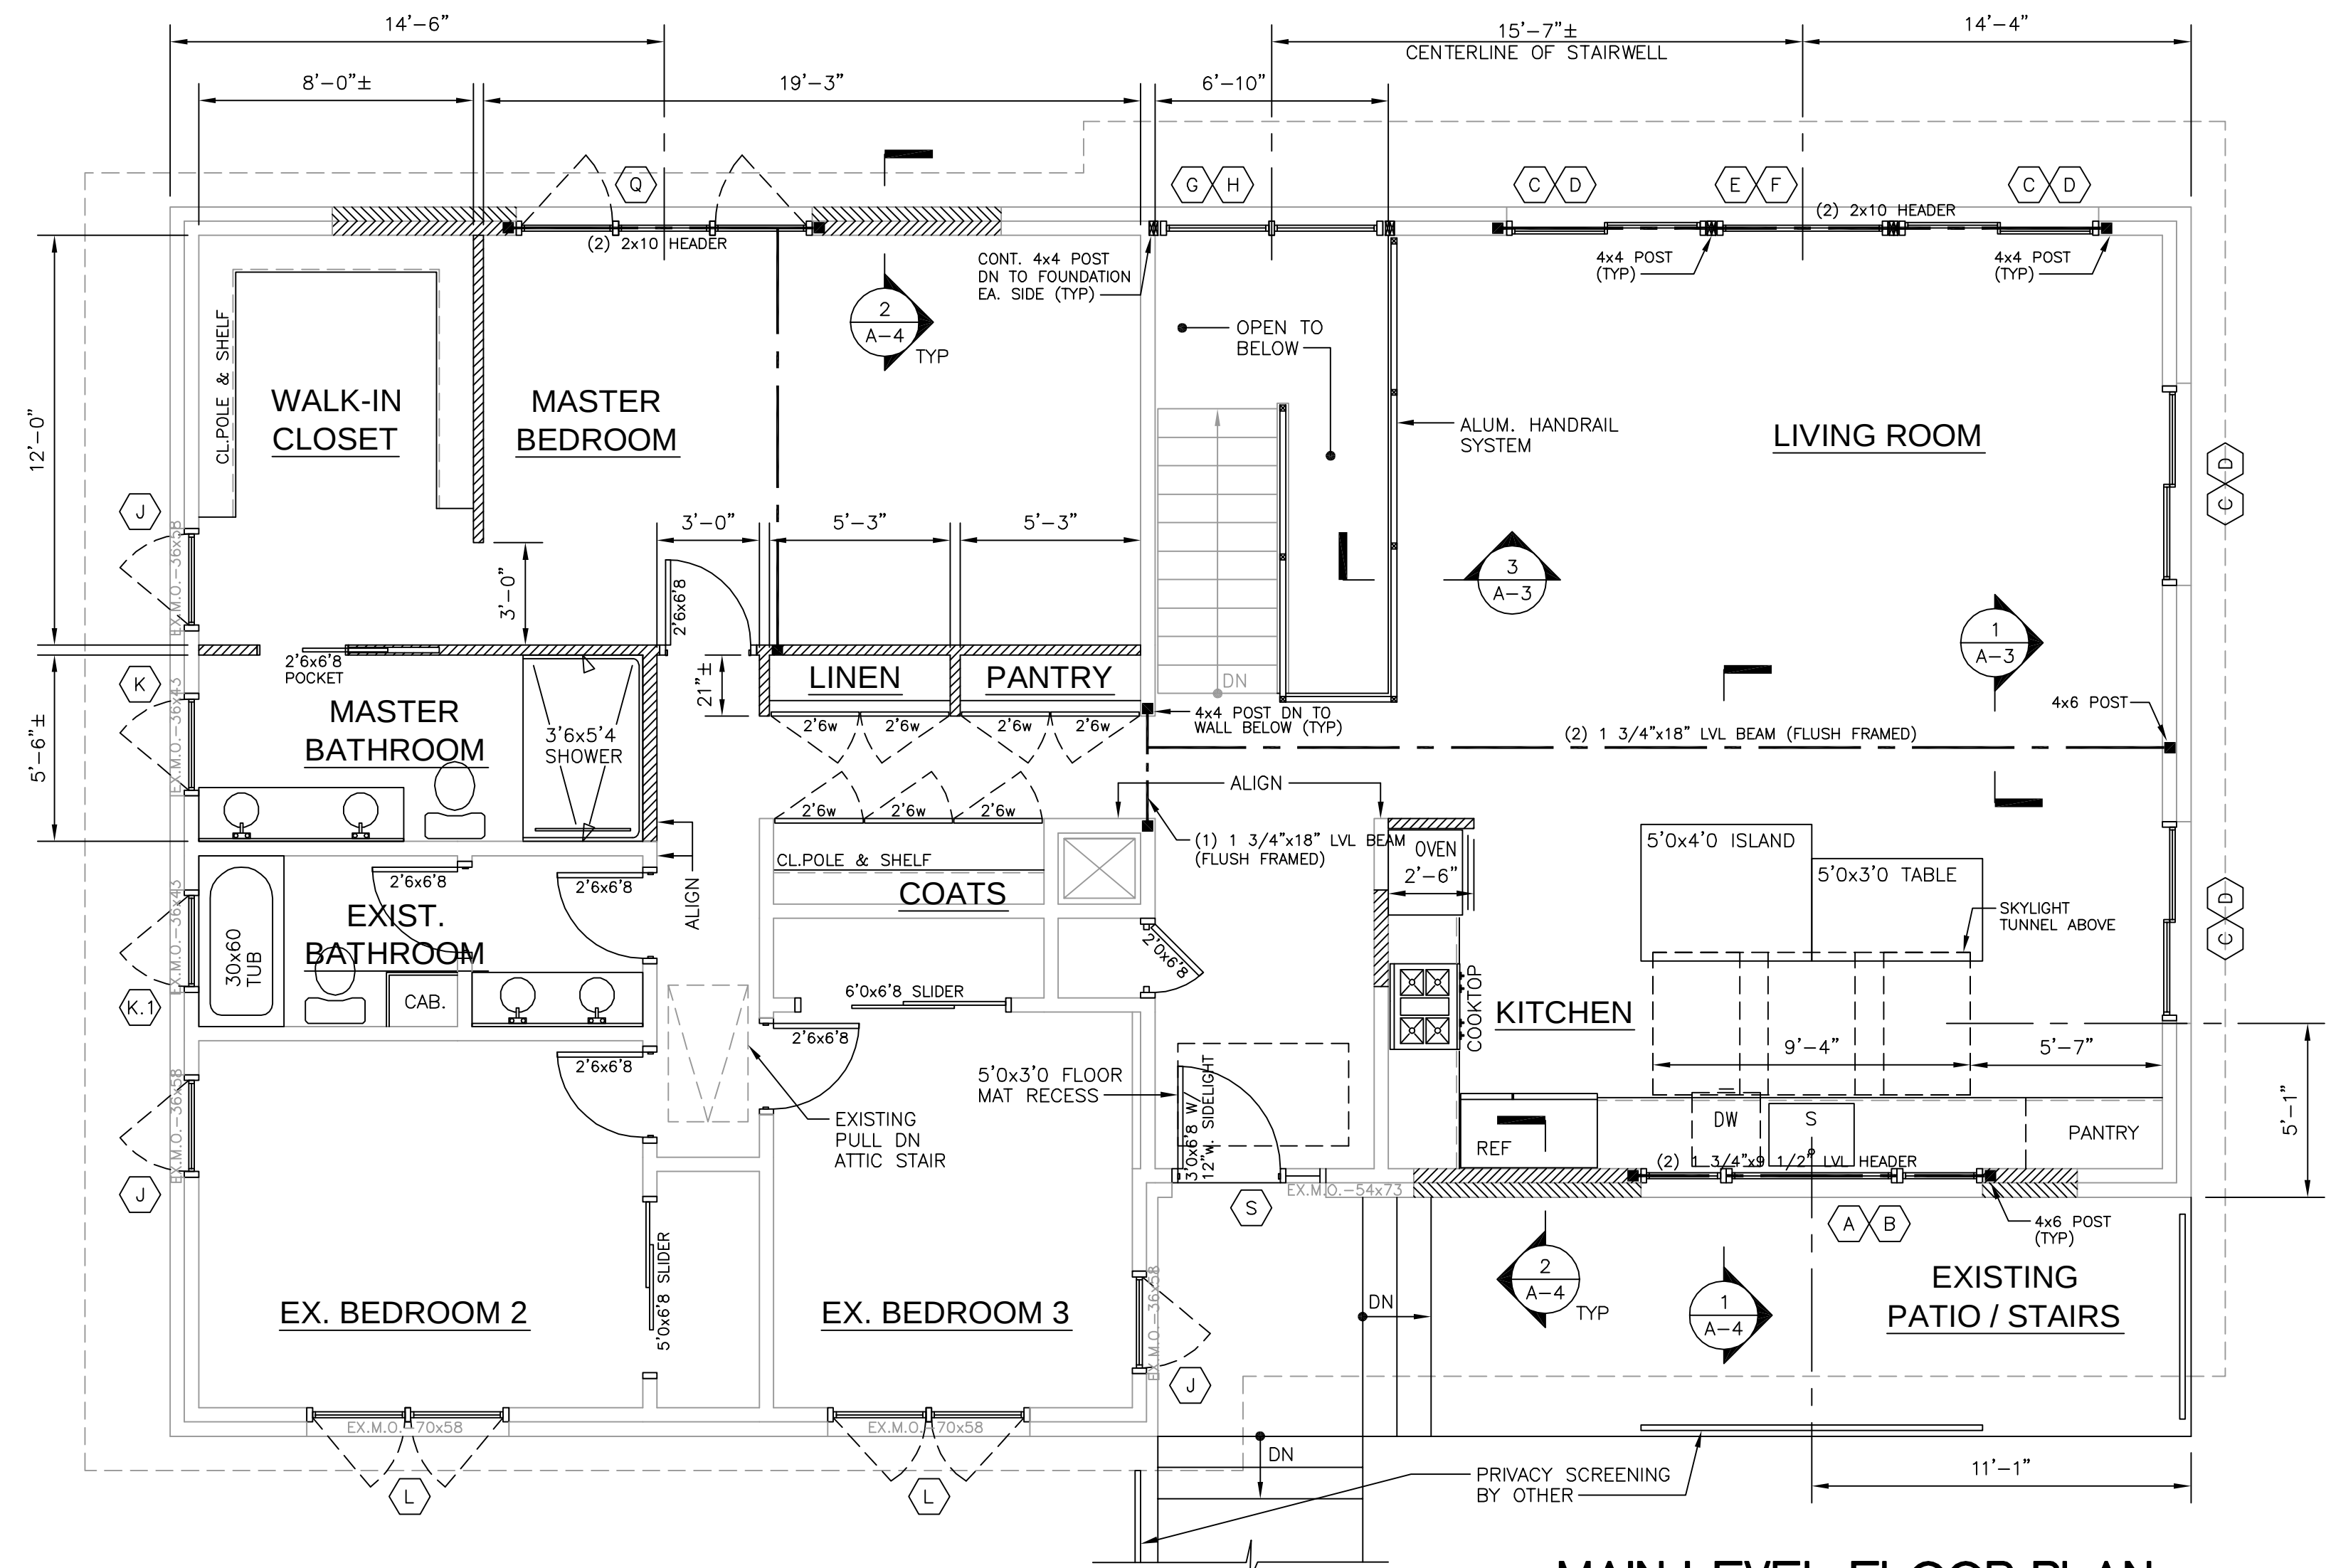

MAIN LEVEL FLOOR PLAN


SCALE: 1/4" = 1'-0"

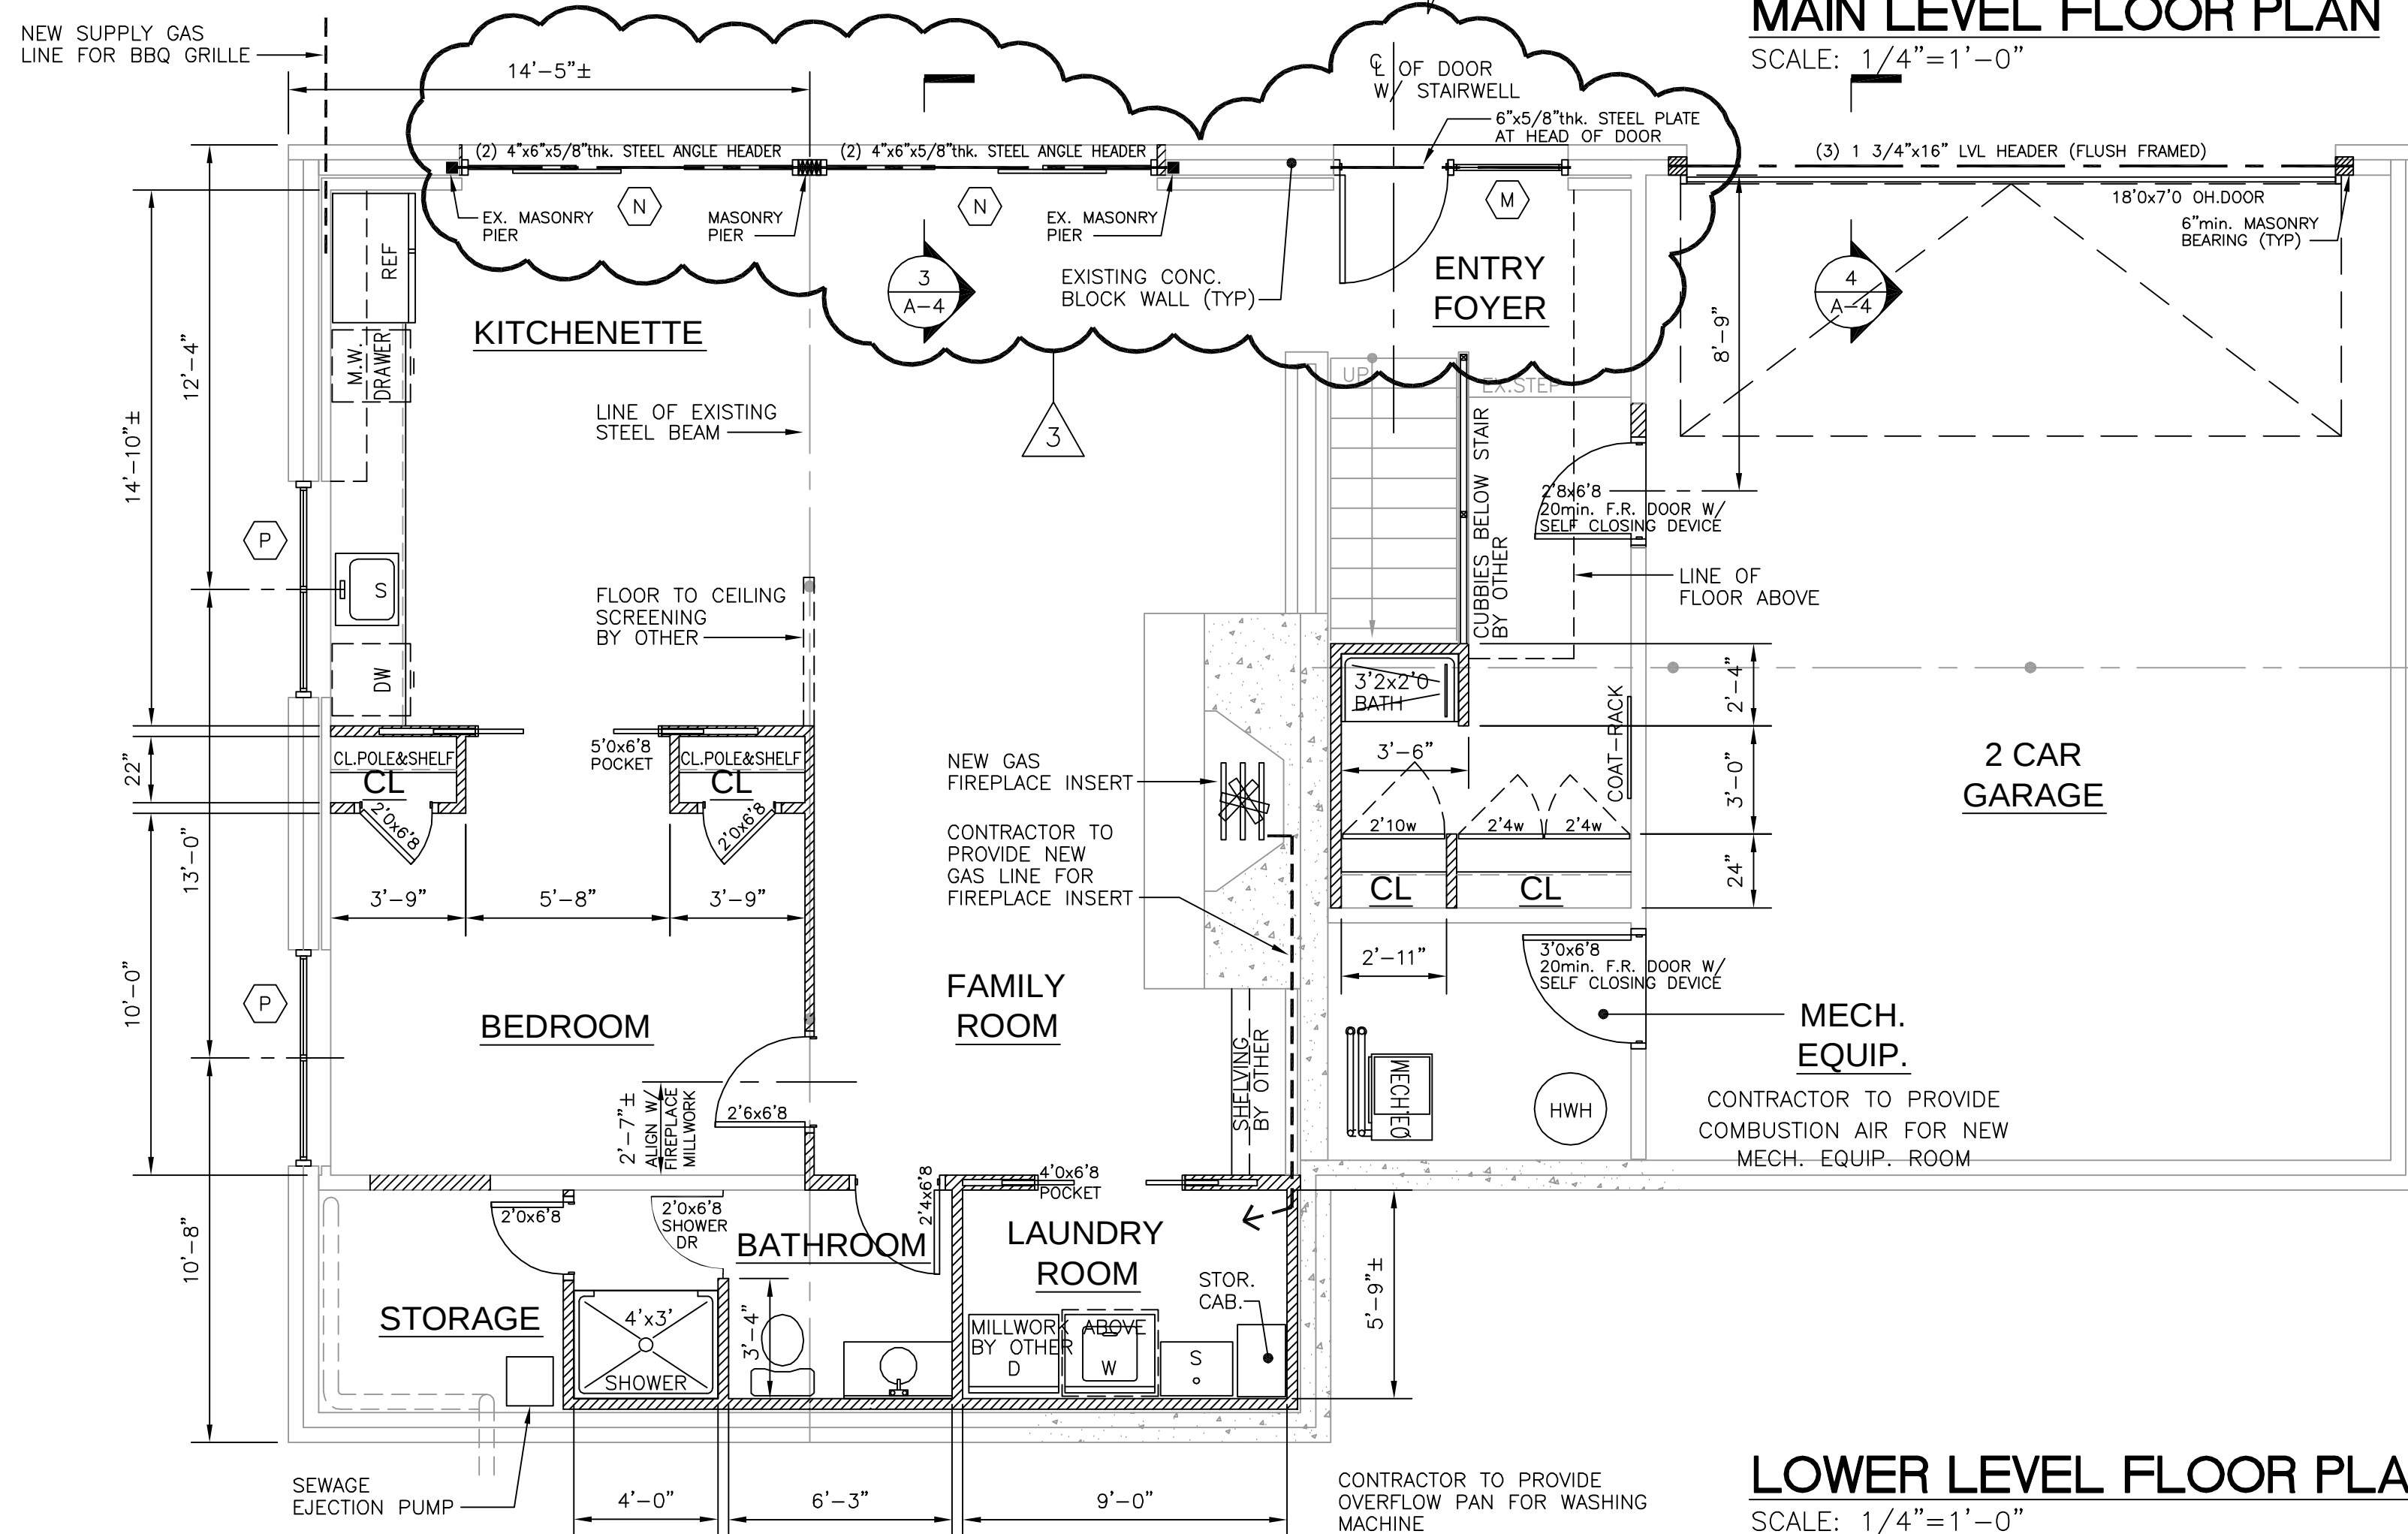

LOWER LEVEL FLOOR PLAN

SCALE: 1/4" = 1'-0"

This drawing and details on it, as an instrument of service, is the property of the architect and may be used for this specific project and shall not be loaned, copied or reproduced without consent of the architect.

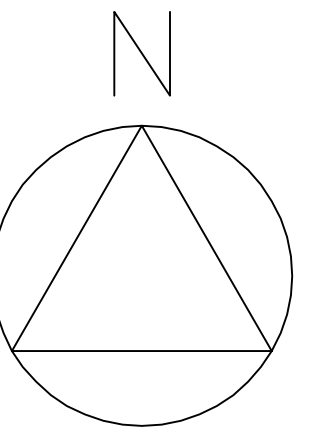

3	1-25-21	BLDG DEPT. REVISIONS
2	9-21-20	BLDG DEPT. REVISIONS
1	7-27-20	GENERAL REVISIONS
No.	Date	Revision

Mingolello & Associates
ARCHITECTS, LLC

90 Huntington Street
Shelton, CT 06484
203.925.1991 • Fax: 203.925.8263
Email: mh.arch@snnet.net

Project Title
RENOVATIONS TO LEVINE RESIDENCE

51 BEECHDALE ROAD
DOBBS FERRY, NY

Date	7-21-20	Dwn/Chkd	KF/AJM
Scale	AS SHOWN	Proj. No.	4010

Drawing Title
FLOOR PLANS

A-2

of

Country	Year	GDP (constant 2005 US\$)		Population (millions)		GDP per capita (constant 2005 US\$)	
		1990	2000	1990	2000	1990	2000
Algeria	1990	10,000	10,000	19.0	19.0	526	526
Algeria	2000	10,000	10,000	20.0	20.0	500	500
Algeria	2005	10,000	10,000	20.0	20.0	500	500
Algeria	2006	10,000	10,000	20.0	20.0	500	500
Algeria	2007	10,000	10,000	20.0	20.0	500	500
Algeria	2008	10,000	10,000	20.0	20.0	500	500
Algeria	2009	10,000	10,000	20.0	20.0	500	500
Algeria	2010	10,000	10,000	20.0	20.0	500	500
Algeria	2011	10,000	10,000	20.0	20.0	500	500
Algeria	2012	10,000	10,000	20.0	20.0	500	500
Algeria	2013	10,000	10,000	20.0	20.0	500	500
Algeria	2014	10,000	10,000	20.0	20.0	500	500
Algeria	2015	10,000	10,000	20.0	20.0	500	500
Algeria	2016	10,000	10,000	20.0	20.0	500	500
Algeria	2017	10,000	10,000	20.0	20.0	500	500
Algeria	2018	10,000	10,000	20.0	20.0	500	500
Algeria	2019	10,000	10,000	20.0	20.0	500	500
Algeria	2020	10,000	10,000	20.0	20.0	500	500
Algeria	2021	10,000	10,000	20.0	20.0	500	500
Algeria	2022	10,000	10,000	20.0	20.0	500	500
Algeria	2023	10,000	10,000	20.0	20.0	500	500
Algeria	2024	10,000	10,000	20.0	20.0	500	500
Algeria	2025	10,000	10,000	20.0	20.0	500	500
Algeria	2026	10,000	10,000	20.0	20.0	500	500
Algeria	2027	10,000	10,000	20.0	20.0	500	500
Algeria	2028	10,000	10,000	20.0	20.0	500	500
Algeria	2029	10,000	10,000	20.0	20.0	500	500
Algeria	2030	10,000	10,000	20.0	20.0	500	500
Algeria	2031	10,000	10,000	20.0	20.0	500	500
Algeria	2032	10,000	10,000	20.0	20.0	500	500
Algeria	2033	10,000	10,000	20.0	20.0	500	500
Algeria	2034	10,000	10,000	20.0	20.0	500	500
Algeria	2035	10,000	10,000	20.0	20.0	500	500
Algeria	2036	10,000	10,000	20.0	20.0	500	500
Algeria	2037	10,000	10,000	20.0	20.0	500	500
Algeria	2038	10,000	10,000	20.0	20.0	500	500
Algeria	2039	10,000	10,000	20.0	20.0	500	500
Algeria	2040	10,000	10,000	20.0	20.0	500	500
Algeria	2041	10,000	10,000	20.0	20.0	500	500
Algeria	2042	10,000	10,000	20.0	20.0	500	500
Algeria	2043	10,000	10,000	20.0	20.0	500	500
Algeria	2044	10,000	10,000	20.0	20.0	500	500
Algeria	2045	10,000	10,000	20.0	20.0	500	500
Algeria	2046	10,000	10,000	20.0	20.0	500	500
Algeria	2047	10,000	10,000	20.0	20.0	500	500
Algeria	2048	10,000	10,000	20.0	20.0	500	500
Algeria	2049	10,000	10,000	20.0	20.0	500	500
Algeria	2050	10,000	10,000	20.0	20.0	500	500
Algeria	2051	10,000	10,000	20.0	20.0	5	

**Mingolello
& Associates**
ARCHITECTS, LLC

90 Huntington Street
Shelton, CT 06484
203.925.1991 • Fax: 203.925.8263
Email: mh.arch@snet.net

the 1990s, the number of people in the United States who are 65 years of age or older has increased by 50 percent. The number of people 75 years of age or older has increased by 100 percent. The number of people 85 years of age or older has increased by 200 percent. The number of people 95 years of age or older has increased by 400 percent. The number of people 100 years of age or older has increased by 800 percent. The number of people 105 years of age or older has increased by 1,600 percent. The number of people 110 years of age or older has increased by 3,200 percent. The number of people 115 years of age or older has increased by 6,400 percent. The number of people 120 years of age or older has increased by 12,800 percent. The number of people 125 years of age or older has increased by 25,600 percent. The number of people 130 years of age or older has increased by 51,200 percent. The number of people 135 years of age or older has increased by 102,400 percent. The number of people 140 years of age or older has increased by 204,800 percent. The number of people 145 years of age or older has increased by 409,600 percent. The number of people 150 years of age or older has increased by 819,200 percent. The number of people 155 years of age or older has increased by 1,638,400 percent. The number of people 160 years of age or older has increased by 3,276,800 percent. The number of people 165 years of age or older has increased by 6,553,600 percent. The number of people 170 years of age or older has increased by 13,107,200 percent. The number of people 175 years of age or older has increased by 26,214,400 percent. The number of people 180 years of age or older has increased by 52,428,800 percent. The number of people 185 years of age or older has increased by 104,857,600 percent. The number of people 190 years of age or older has increased by 209,715,200 percent. The number of people 195 years of age or older has increased by 419,430,400 percent. The number of people 200 years of age or older has increased by 838,860,800 percent. The number of people 205 years of age or older has increased by 1,677,721,600 percent. The number of people 210 years of age or older has increased by 3,355,443,200 percent. The number of people 215 years of age or older has increased by 6,710,886,400 percent. The number of people 220 years of age or older has increased by 13,421,772,800 percent. The number of people 225 years of age or older has increased by 26,843,545,600 percent. The number of people 230 years of age or older has increased by 53,687,091,200 percent. The number of people 235 years of age or older has increased by 107,374,182,400 percent. The number of people 240 years of age or older has increased by 214,748,364,800 percent. The number of people 245 years of age or older has increased by 429,496,729,600 percent. The number of people 250 years of age or older has increased by 858,993,459,200 percent. The number of people 255 years of age or older has increased by 1,717,986,918,400 percent. The number of people 260 years of age or older has increased by 3,435,973,836,800 percent. The number of people 265 years of age or older has increased by 6,871,947,673,600 percent. The number of people 270 years of age or older has increased by 13,743,895,347,200 percent. The number of people 275 years of age or older has increased by 27,487,790,694,400 percent. The number of people 280 years of age or older has increased by 54,975,581,388,800 percent. The number of people 285 years of age or older has increased by 109,951,162,777,600 percent. The number of people 290 years of age or older has increased by 219,902,325,555,200 percent. The number of people 295 years of age or older has increased by 439,804,651,110,400 percent. The number of people 300 years of age or older has increased by 879,609,302,220,800 percent. The number of people 305 years of age or older has increased by 1,759,218,604,441,600 percent. The number of people 310 years of age or older has increased by 3,518,437,208,883,200 percent. The number of people 315 years of age or older has increased by 7,036,874,417,766,400 percent. The number of people 320 years of age or older has increased by 14,073,748,835,532,800 percent. The number of people 325 years of age or older has increased by 28,147,497,671,065,600 percent. The number of people 330 years of age or older has increased by 56,294,995,342,131,200 percent. The number of people 335 years of age or older has increased by 112,589,990,684,262,400 percent. The number of people 340 years of age or older has increased by 225,179,981,368,524,800 percent. The number of people 345 years of age or older has increased by 450,359,962,737,049,600 percent. The number of people 350 years of age or older has increased by 900,719,925,474,099,200 percent. The number of people 355 years of age or older has increased by 1,801,439,850,948,198,400 percent. The number of people 360 years of age or older has increased by 3,602,879,701,896,396,800 percent. The number of people 365 years of age or older has increased by 7,205,759,403,792,793,600 percent. The number of people 370 years of age or older has increased by 14,411,518,807,585,587,200 percent. The number of people 375 years of age or older has increased by 28,823,037,615,171,174,400 percent. The number of people 380 years of age or older has increased by 57,646,075,230,342,348,800 percent. The number of people 385 years of age or older has increased by 115,292,150,460,684,697,600 percent. The number of people 390 years of age or older has increased by 230,584,300,921,369,395,200 percent. The number of people 395 years of age or older has increased by 461,168,601,842,738,790,400 percent. The number of people 400 years of age or older has increased by 922,337,203,685,477,580,800 percent. The number of people 405 years of age or older has increased by 1,844,674,407,370,955,161,600 percent. The number of people 410 years of age or older has increased by 3,689,348,814,741,910,323,200 percent. The number of people 415 years of age or older has increased by 7,378,697,629,483,820,646,400 percent. The number of people 420 years of age or older has increased by 14,757,395,258,967,641,292,800 percent. The number of people 425 years of age or older has increased by 29,514,790,517,935,282,585,600 percent. The number of people 430 years of age or older has increased by 59,029,581,035,870,565,171,200 percent. The number of people 435 years of age or older has increased by 118,059,162,071,741,130,342,400 percent. The number of people 440 years of age or older has increased by 236,118,324,143,482,260,684,800 percent. The number of people 445 years of age or older has increased by 472,236,648,286,964,521,369,600 percent. The number of people 450 years of age or older has increased by 944,473,296,573,929,042,739,200 percent. The number of people 455 years of age or older has increased by 1,888,946,593,147,858,085,478,400 percent. The number of people 460 years of age or older has increased by 3,777,893,186,295,716,170,956,800 percent. The number of people 465 years of age or older has increased by 7,555,786,372,591,432,341,913,600 percent. The number of people 470 years of age or older has increased by 15,111,572,745,182,864,683,827,200 percent. The number of people 475 years of age or older has increased by 30,223,145,490,365,729,367,654,400 percent. The number of people 480 years of age or older has increased by 60,446,290,980,731,458,735,308,800 percent. The number of people 485 years of age or older has increased by 120,892,581,961,462,917,470,617,600 percent. The number of people 490 years of age or older has increased by 241,785,163,922,925,834,941,235,200 percent. The number of people 495 years of age or older has increased by 483,570,327,845,851,669,882,470,400 percent. The number of people 500 years of age or older has increased by 967,140,655,691,703,339,764,940,800 percent. The number of people 505 years of age or older has increased by 1,934,281,311,383,406,679,529,881,600 percent. The number of people 510 years of age or older has increased by 3,868,562,622,766,813,359,059,763,200 percent. The number of people 515 years of age or older has increased by 7,737,125,245,533,626,718,119,526,400 percent. The number of people 520 years of age or older has increased by 15,474,250,491,067,253,436,239,052,800 percent. The number of people 525 years of age or older has increased by 30,948,500,982,134,506,872,478,105,600 percent. The number of people 530 years of age or older has increased by 61,897,001,964,269,013,744,956,211,200 percent. The number of people 535 years of age or older has increased by 123,794,003,928,538,027,489,912,422,400 percent. The number of people 540 years of age or older has increased by 247,588,007,857,076,054,979,824,844,800 percent. The number of people 545 years of age or older has increased by 495,176,015,714,152,109,959,649,689,600 percent. The number of people 550 years of age or older has increased by 990,352,031,428,304,219,919,299,379,200 percent. The number of people 555 years of age or older has increased by 1,980,704,062,856,608,439,838,598,758,400 percent. The number of people 560 years of age or older has increased by 3,961,408,125,713,216,879,677,197,516,800 percent. The number of people 565 years of age or older has increased by 7,922,816,251,426,433,759,354,395,033,600 percent. The number of people 570 years of age or older has increased by 15,845,632,502,852,867,518,708,790,067,200 percent. The number of people 575

Drawing Title

ELEVATIONS

A-3

of

