




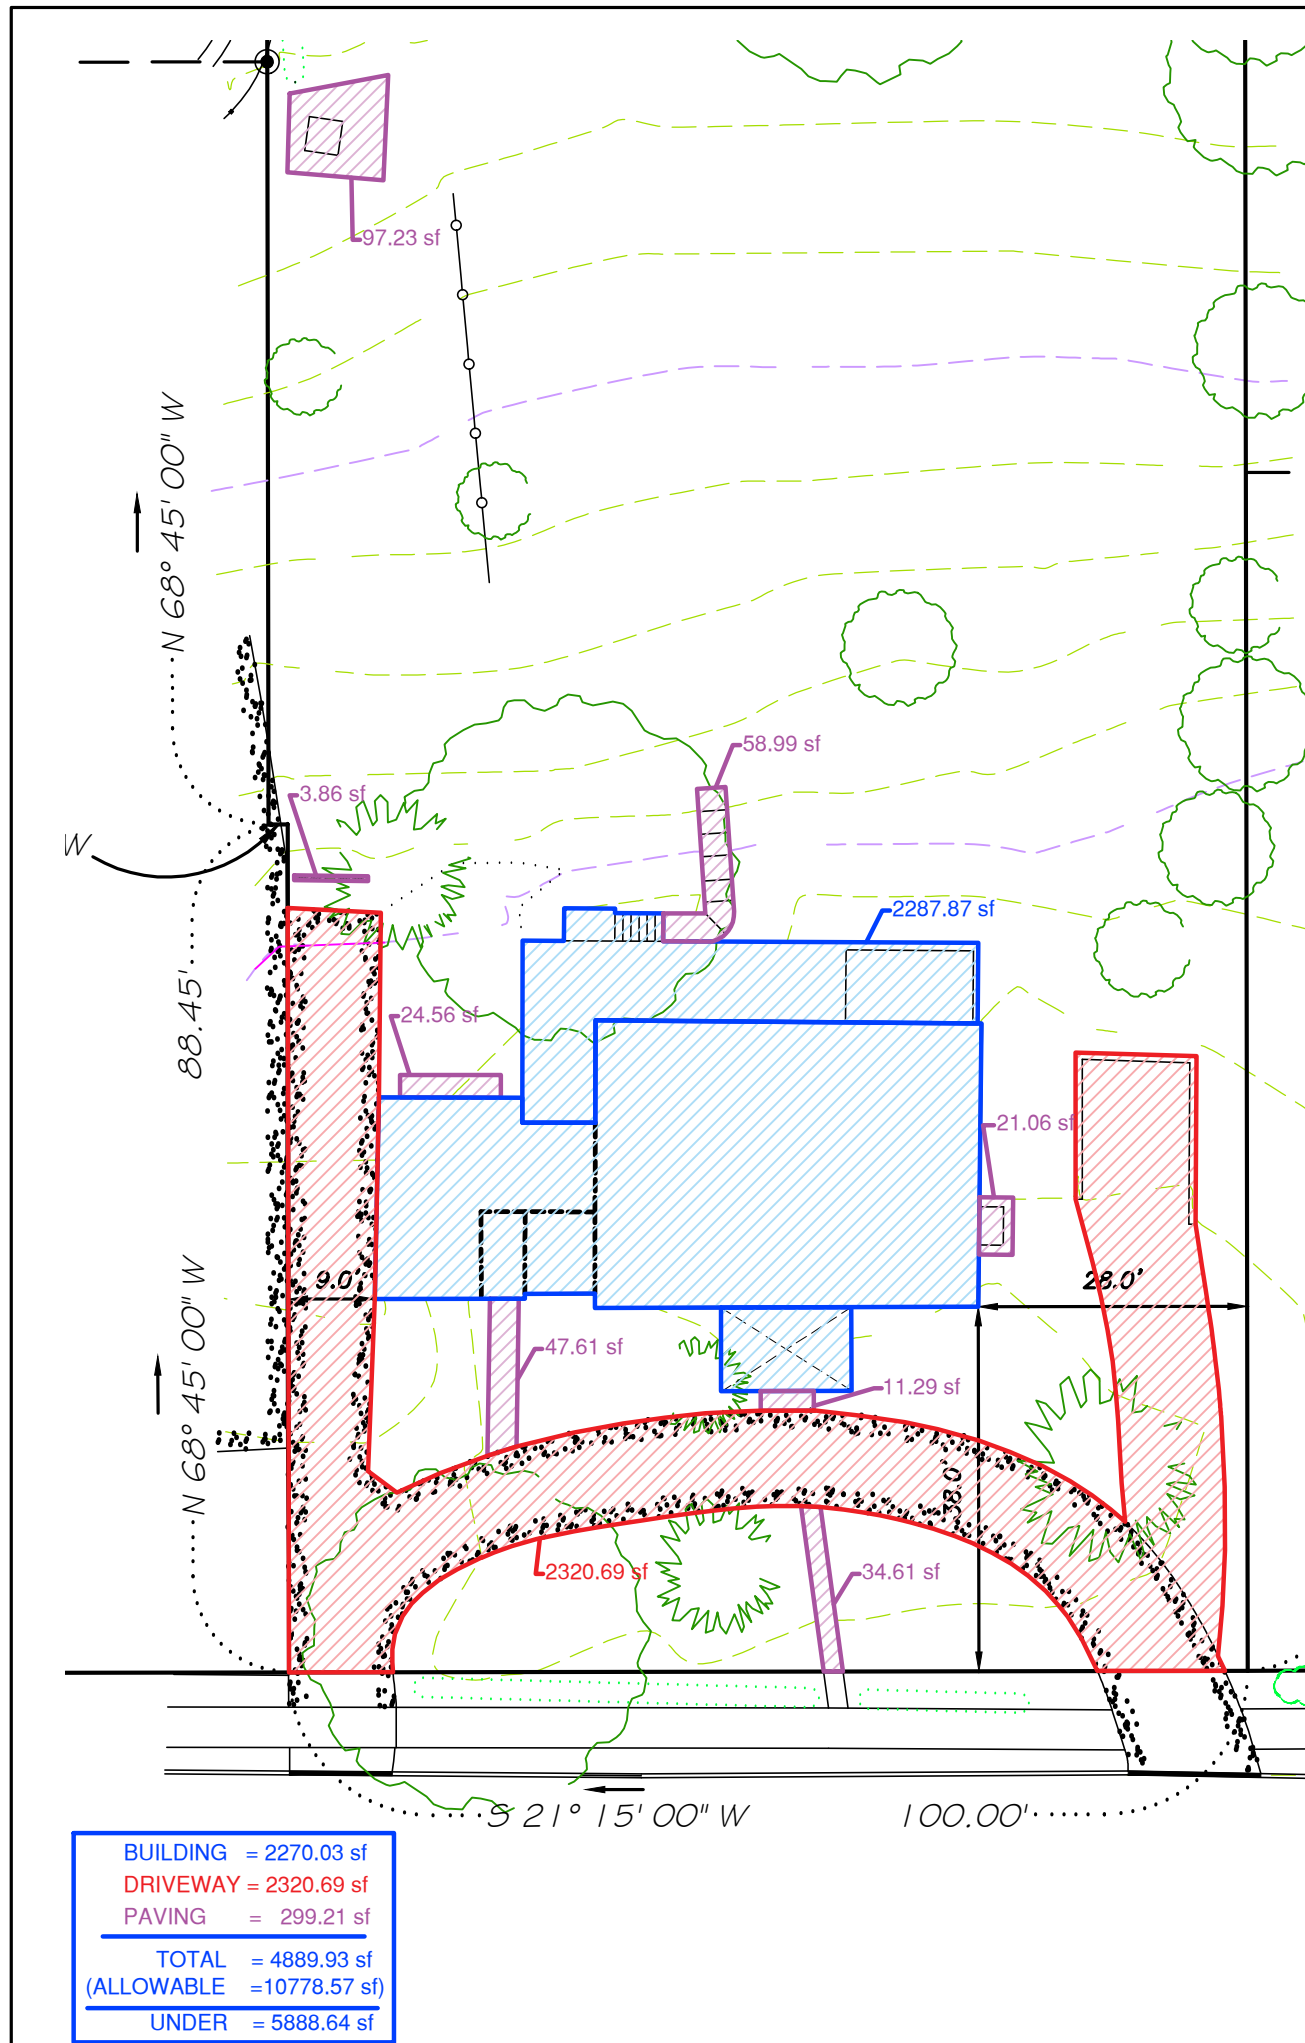


1 EXISTING LOT COVERAGE DIAGRAM
SCALE: 1" = 20'-0"

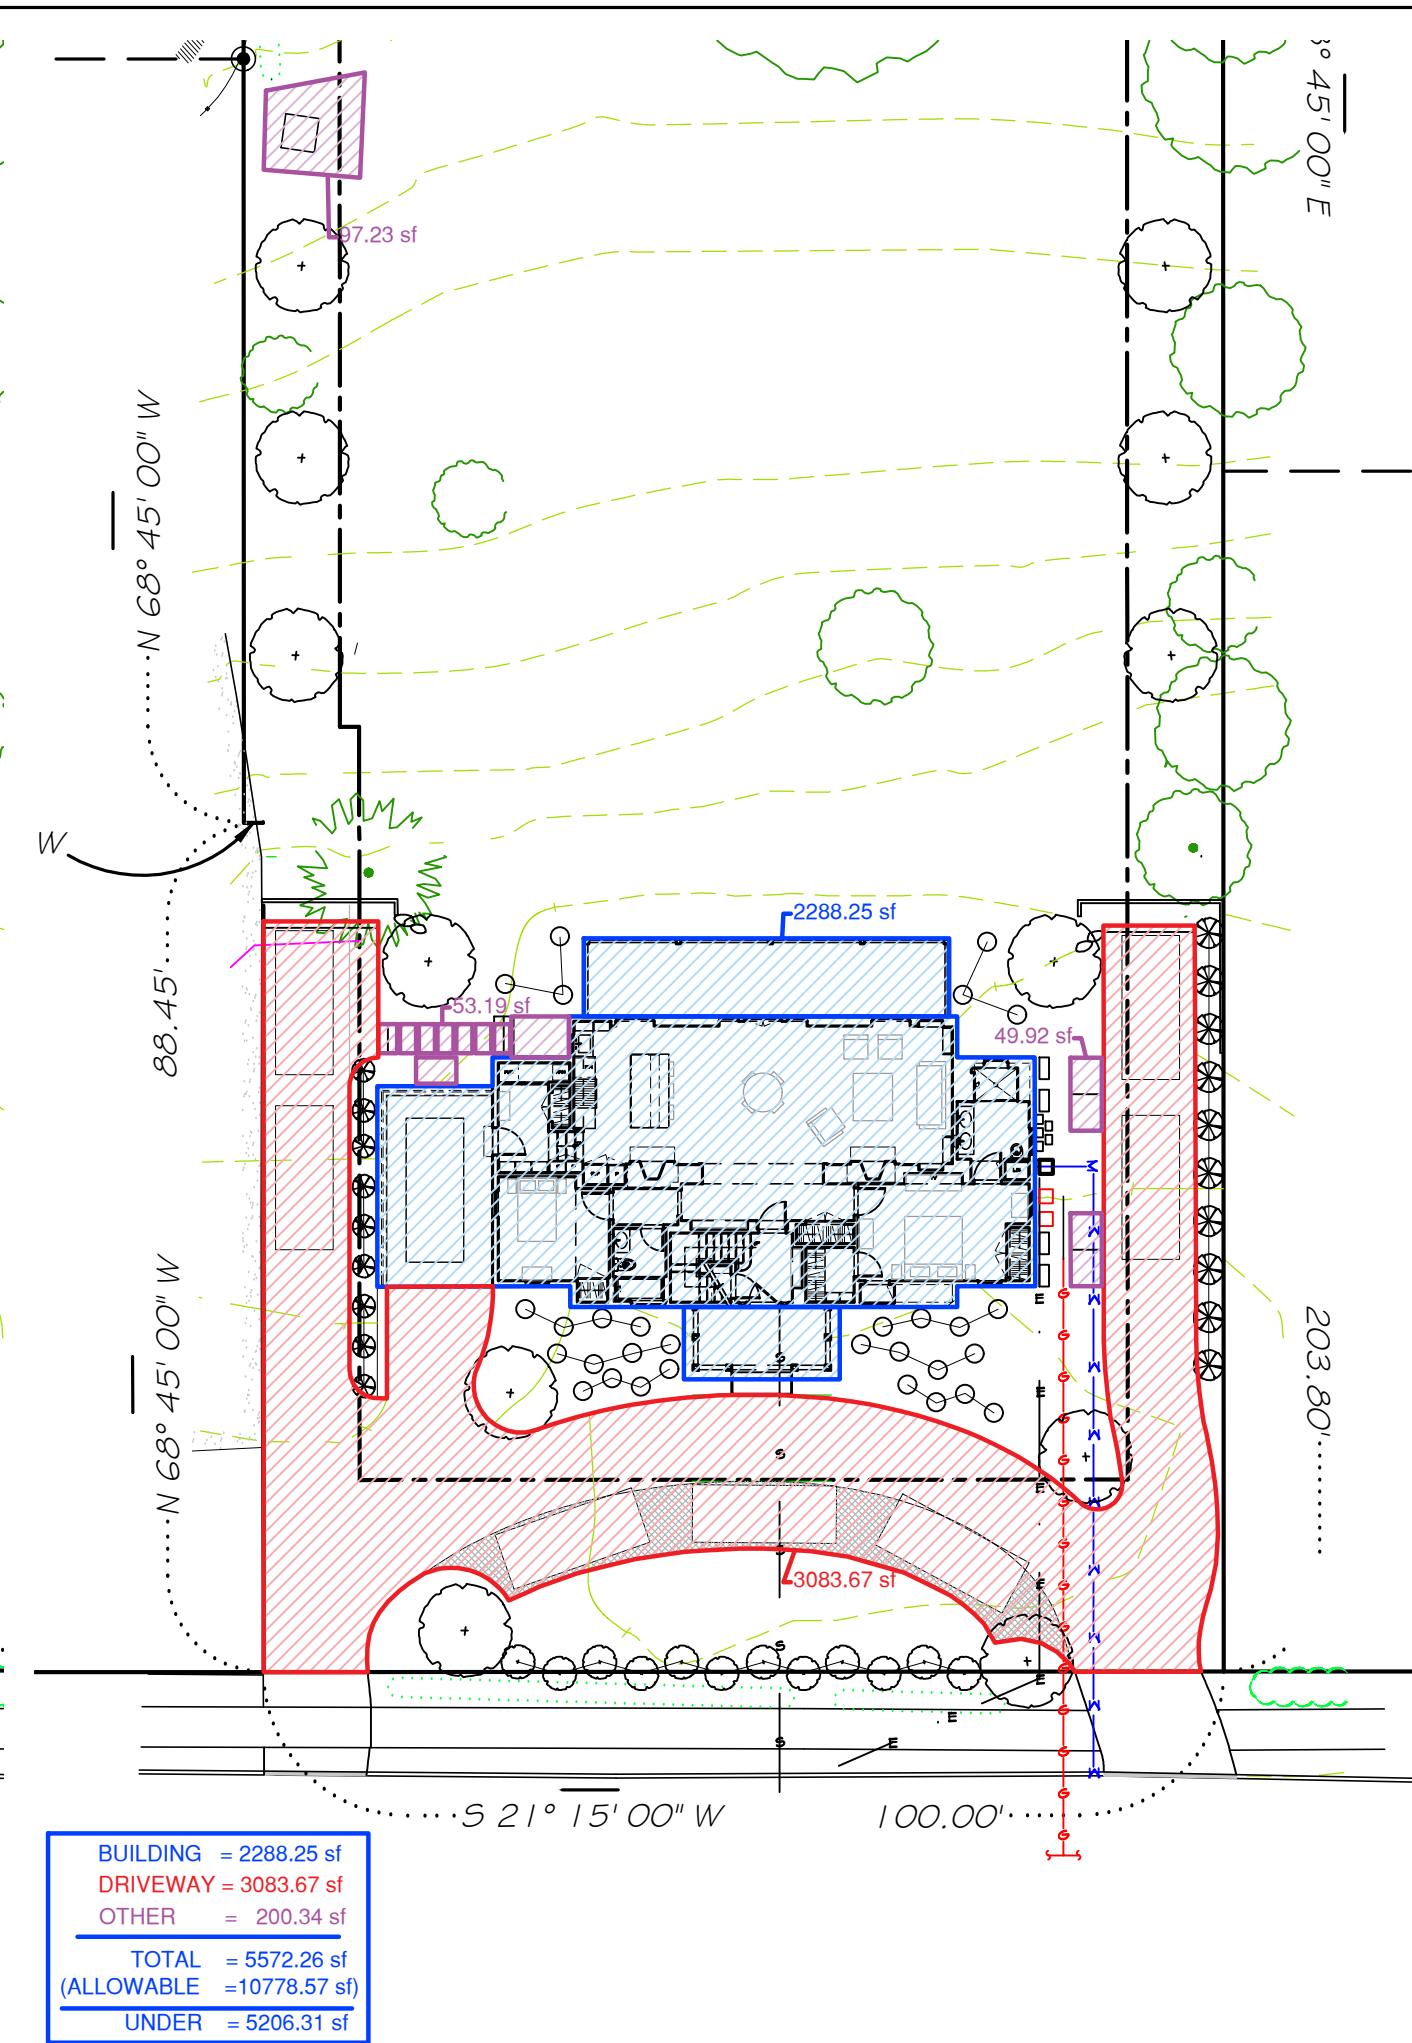


2 PROPOSED LOT COVERAGE DIAGRAM
SCALE: 1" = 20'-0"

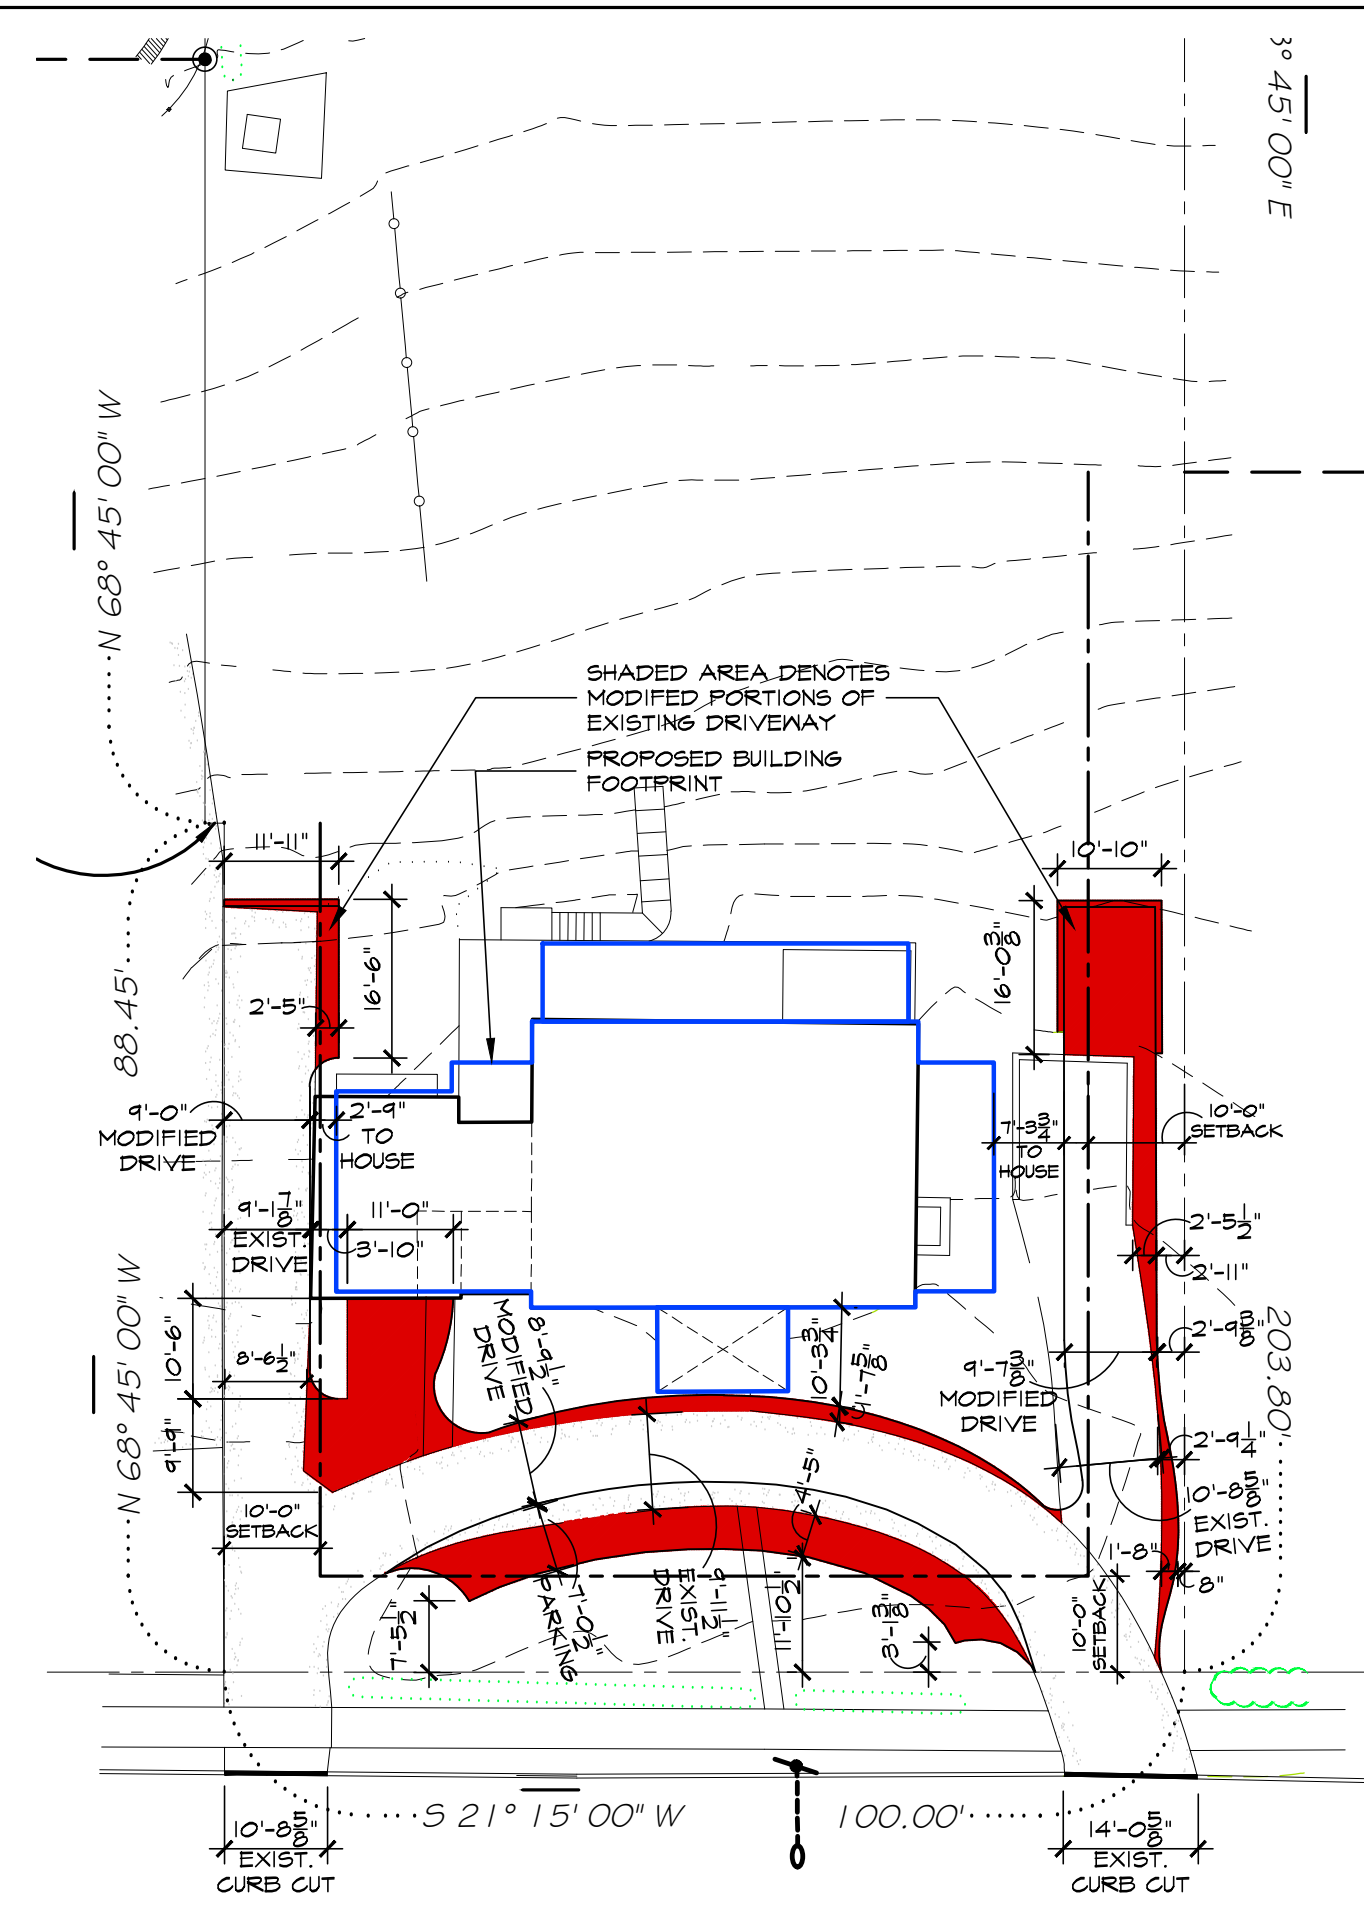


3 DRIVEWAY COMPARISON DIAGRAM
SCALE: 1" = 20'-0"

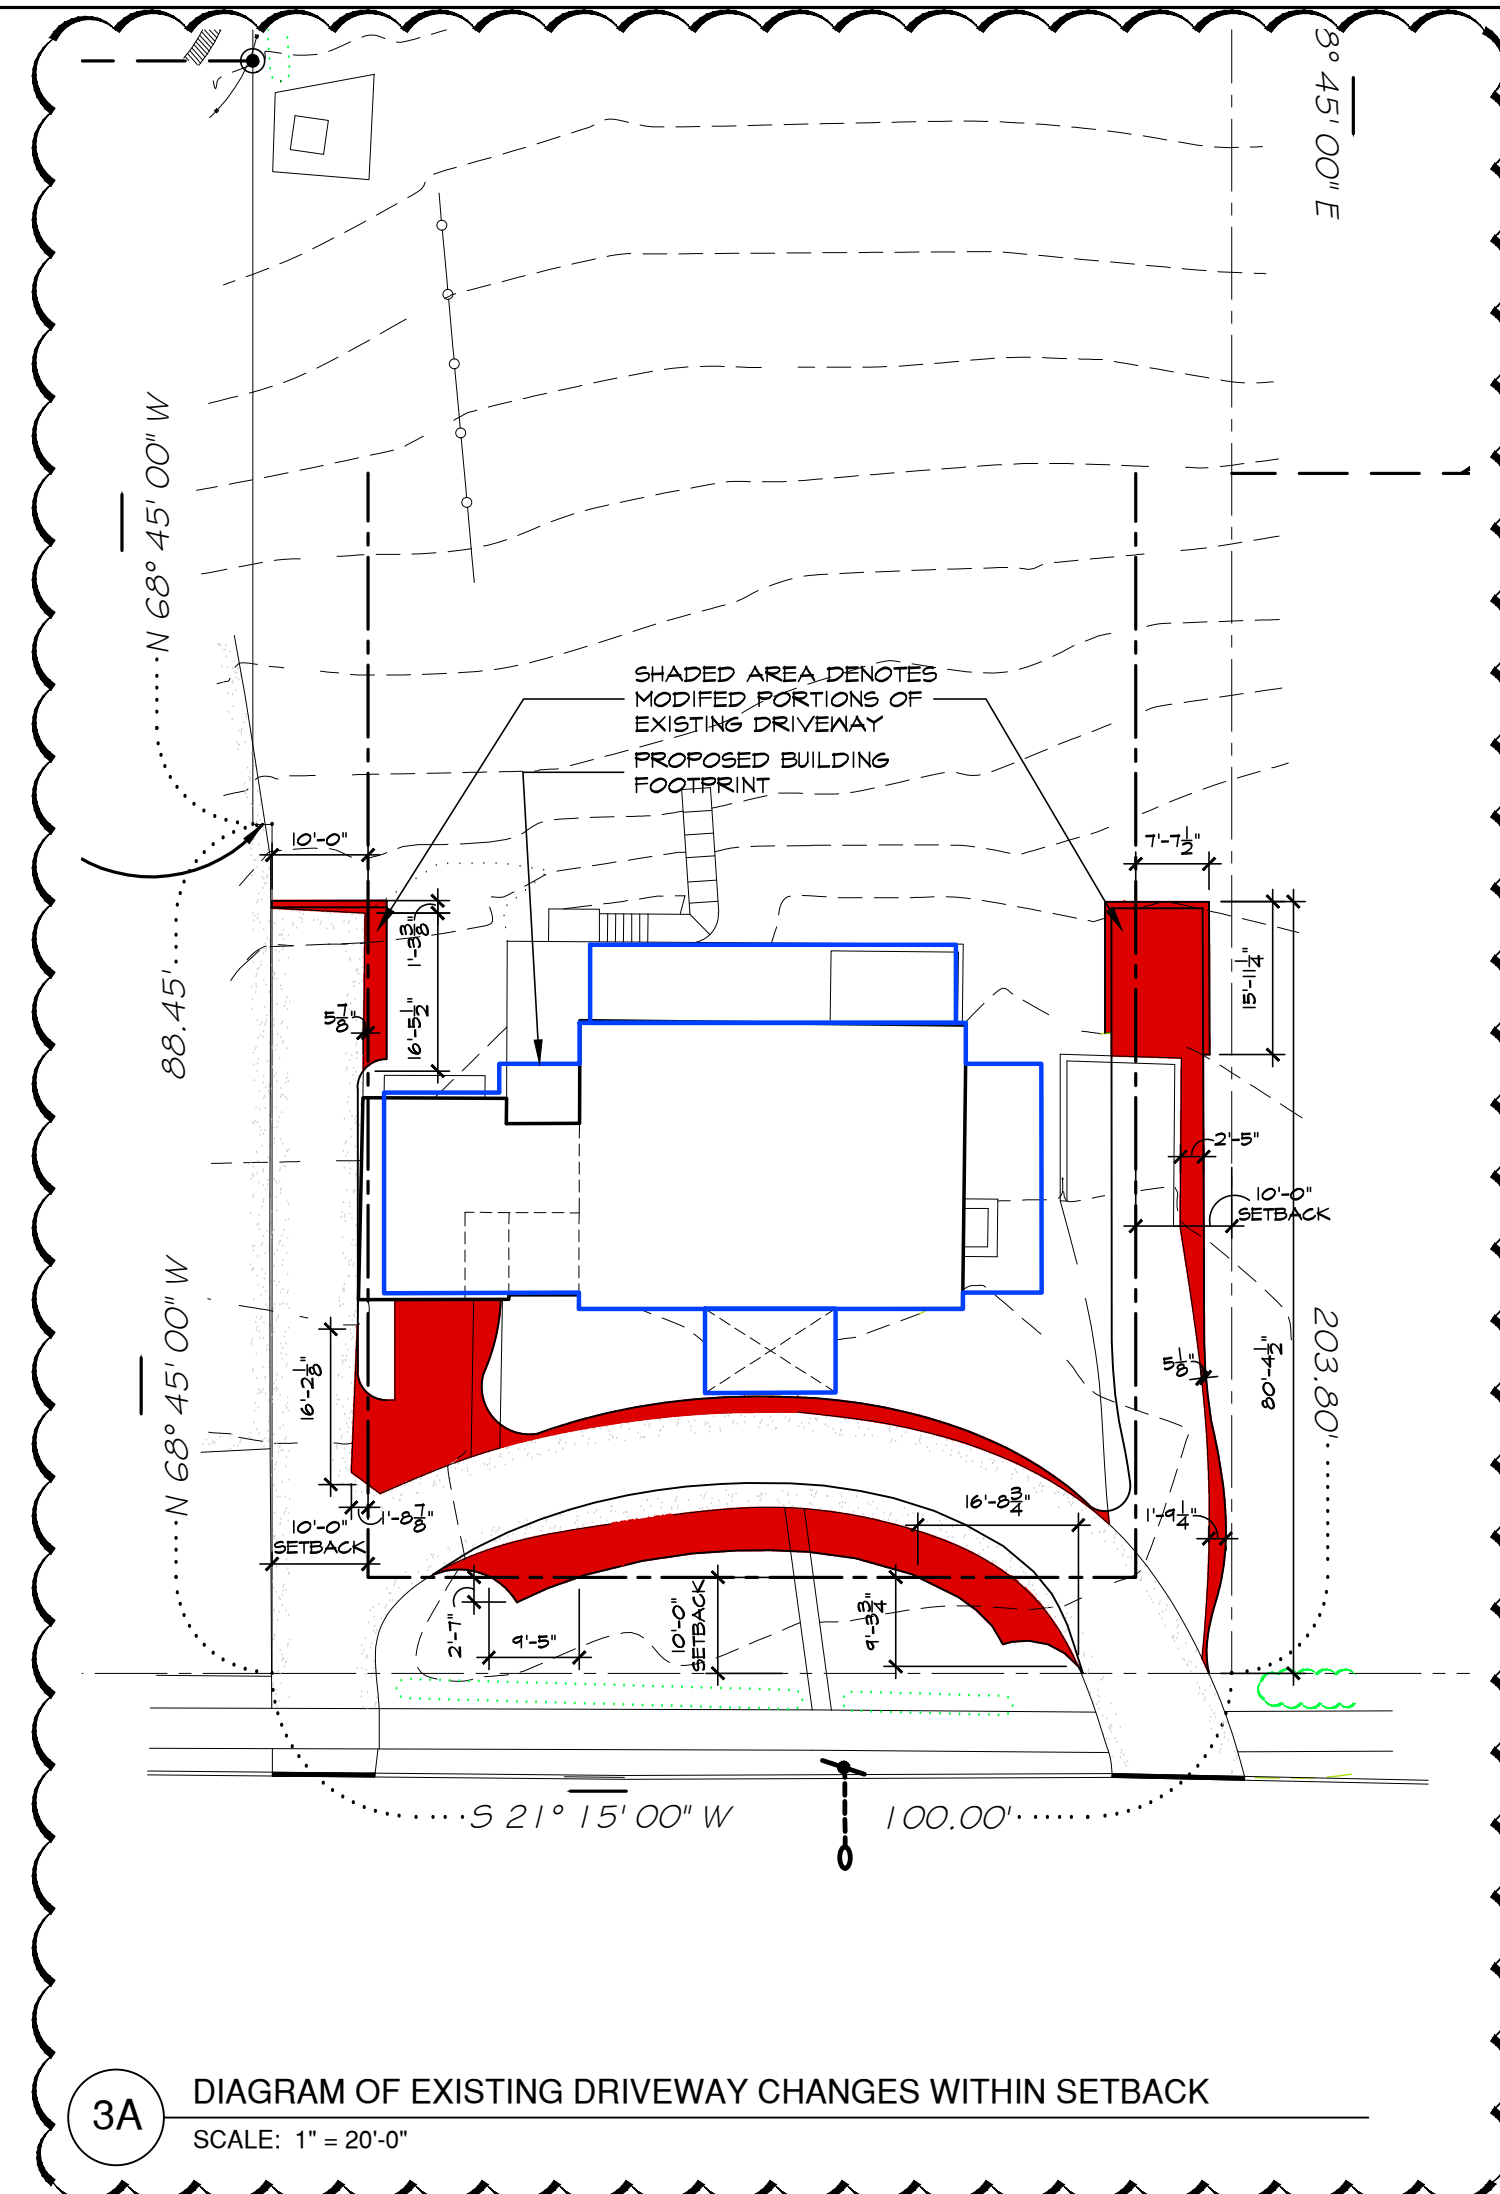


3A DIAGRAM OF EXISTING DRIVEWAY CHANGES WITHIN SETBACK
SCALE: 1" = 20'-0"

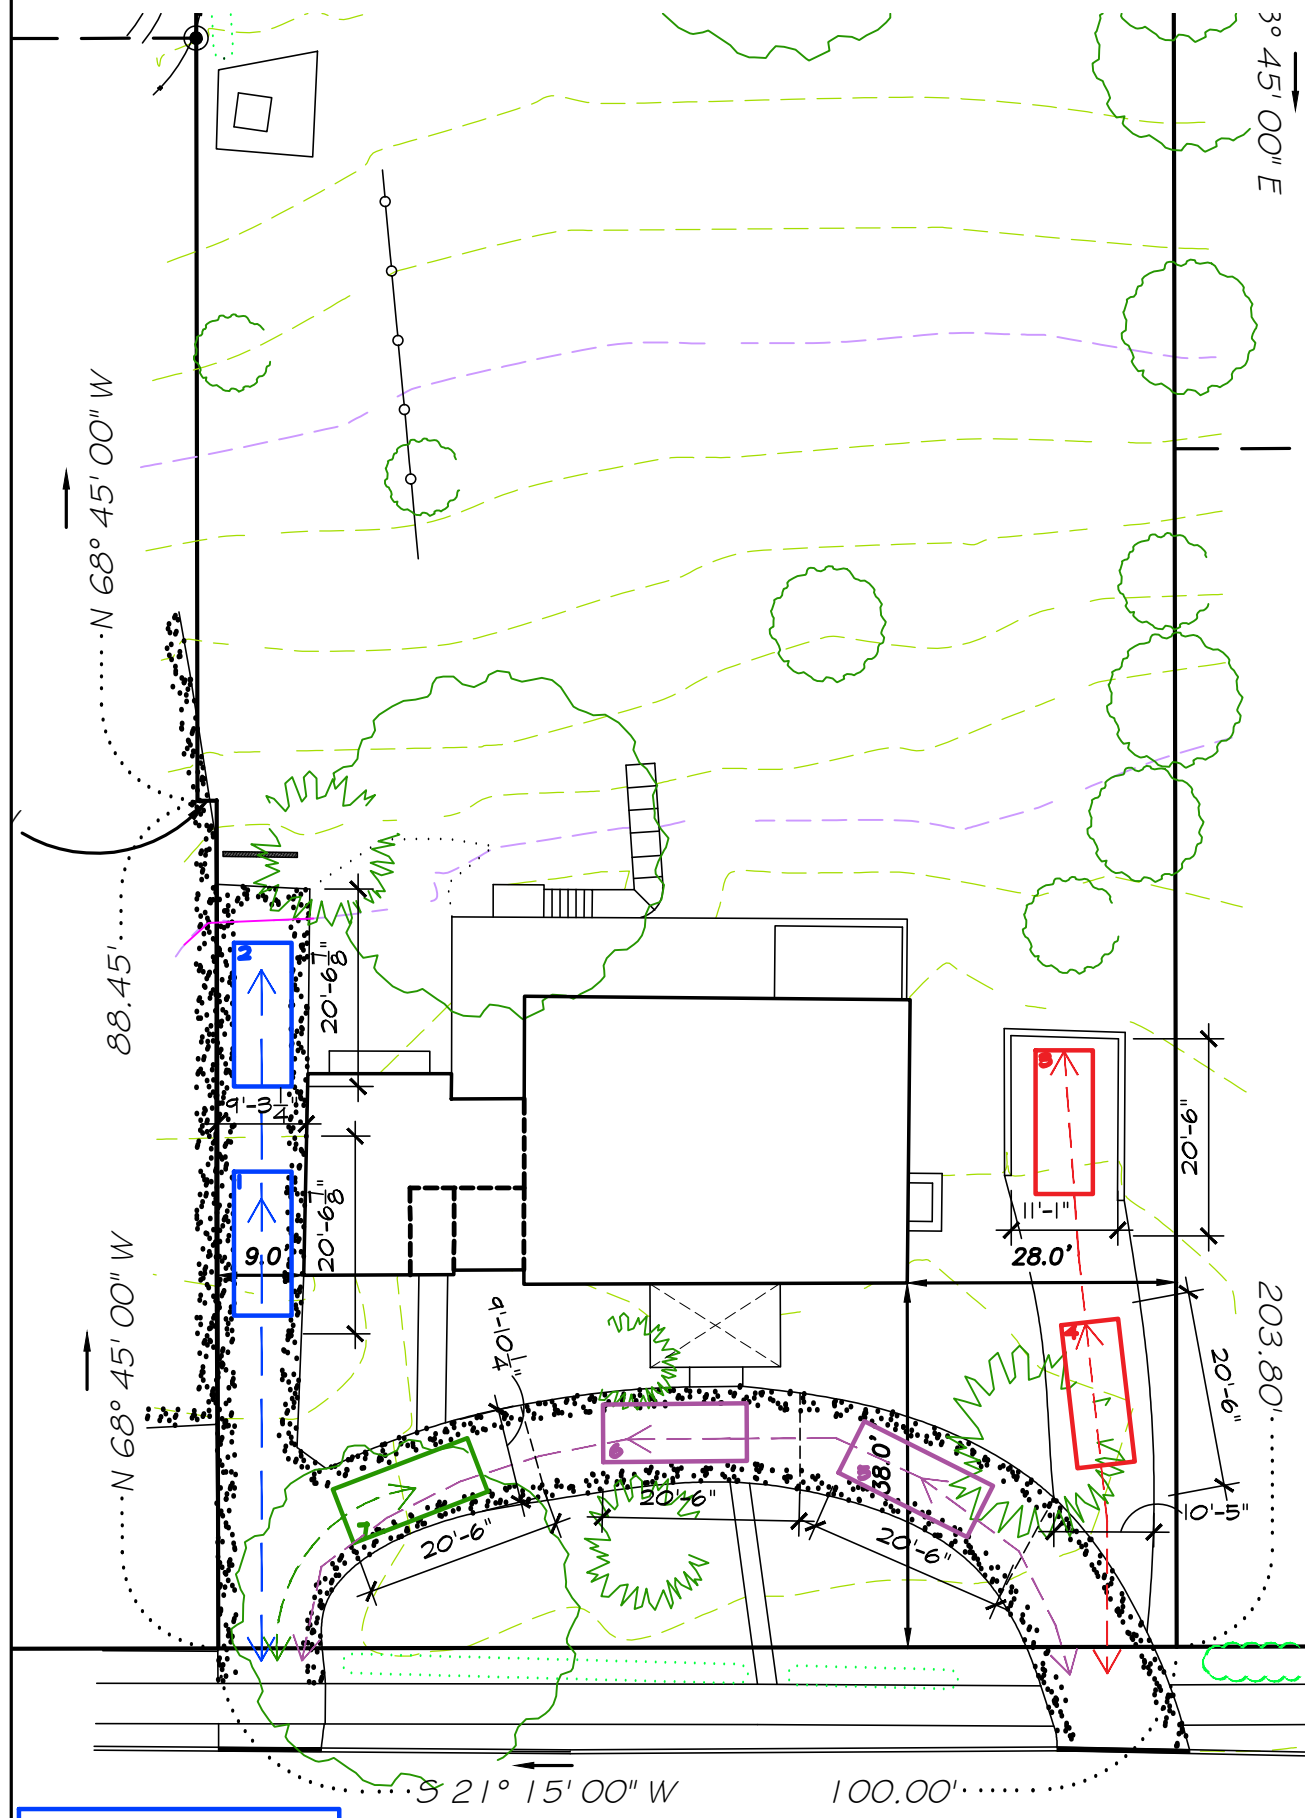


4 EXISTING PARKING DIAGRAM
SCALE: 1" = 20'-0"

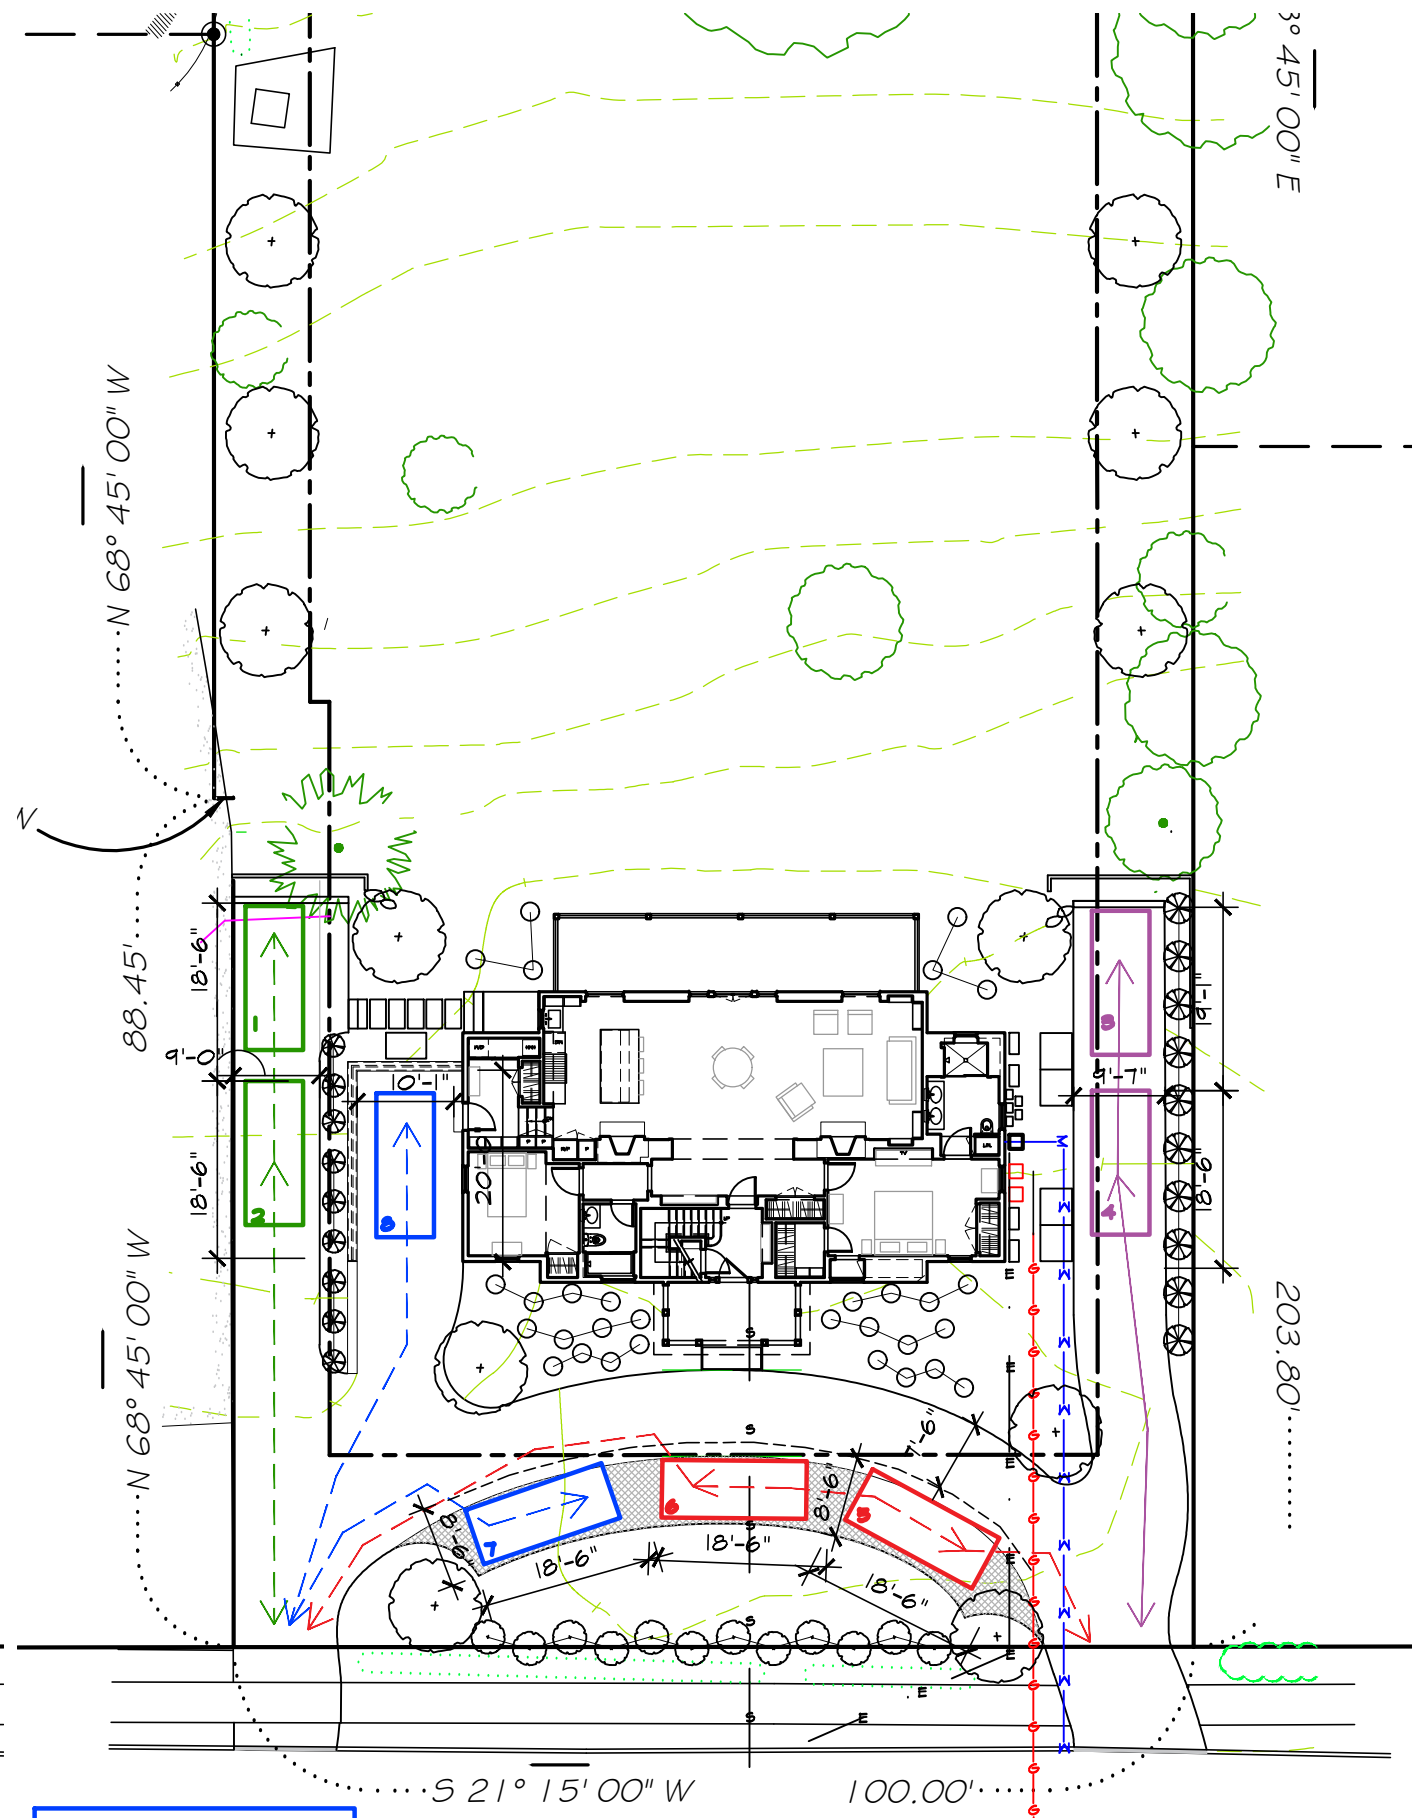


5 PROPOSED PARKING DIAGRAM
SCALE: 1" = 20'-0"

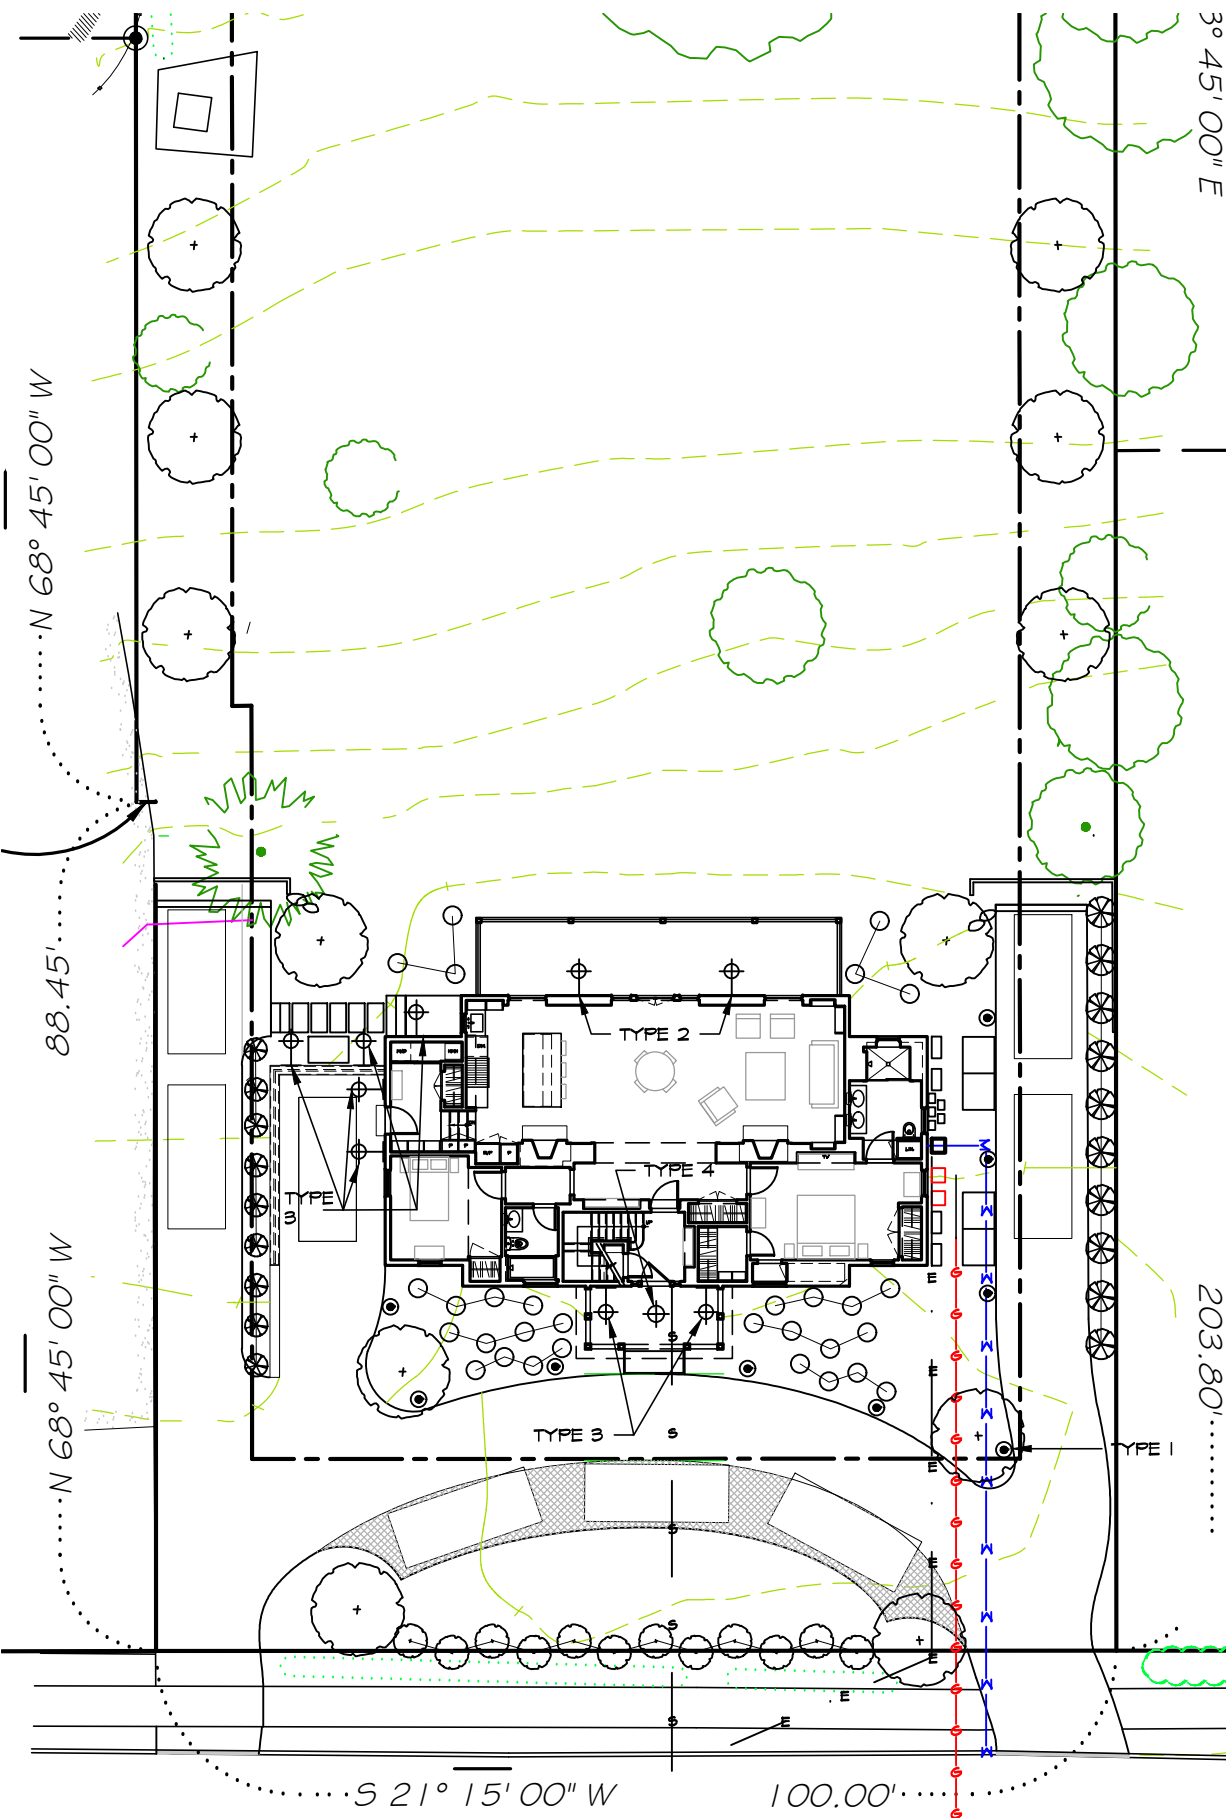

6 PROPOSED LIGHTING PLAN
SCALE: 1" = 20'-0"

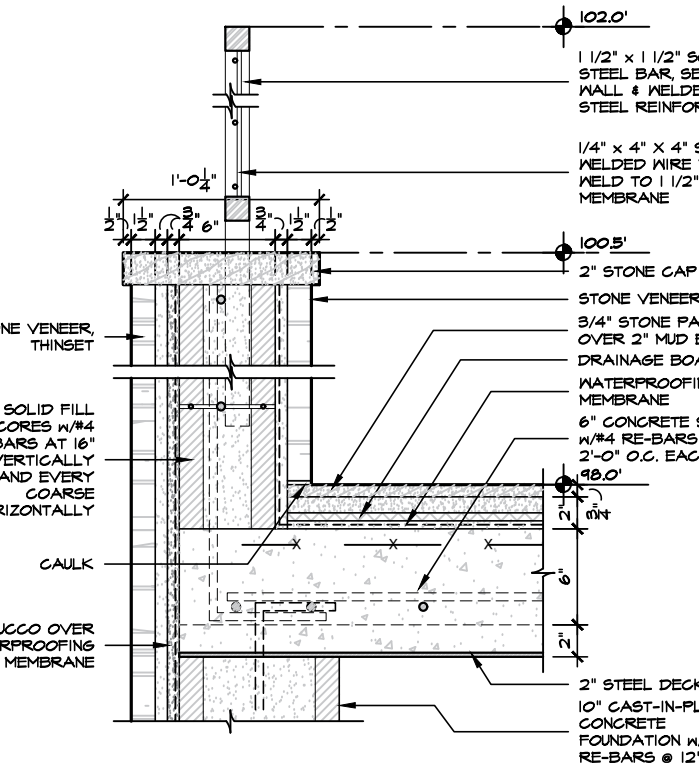

8 WALL SECTION @ PARKING TERRACE
SCALE: 1-1/2" = 1'-0"

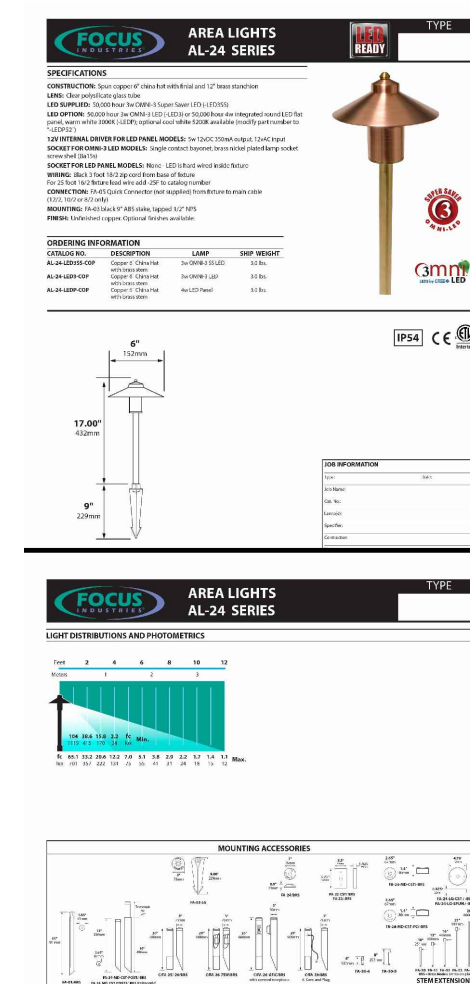

7 PROPOSED LIGHT FIXTURES
SCALE: NTS

GENERAL LANDSCAPE NOTES:

LANDSCAPE NOTES:

12-14-22 RE-ISSUED FOR PLANNING BD. APPROVAL
11-15-22 ISSUED FOR PLANNING BD. APPROVAL
10-11-22 ISSUED FOR PLANNING BD. APPROVAL

No. Date Revision

Project Title
63 LIVINGSTON , LLC
63 Livingston Avenue
Dobbs Ferry, NY 10522

Architect
Opac Architects
24 North Astor
Irvine, NY 10533
Tel: (914) 591-4306
Fax: (914) 591-4308

Stamp

Drawing Title
**COVERAGE, DRIVEWAY, PARKING DIAGRAMS,
LIGHTING PLAN AND FIXTURES**

Scale Job no. Issue Date Drawing no.
AS NOTED 2104 11-15-22
Drawn By Checked By Approved By
NW