



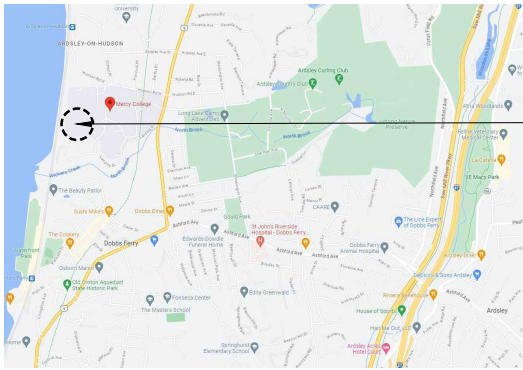


AREA PLAN
N.T.S.

SITE

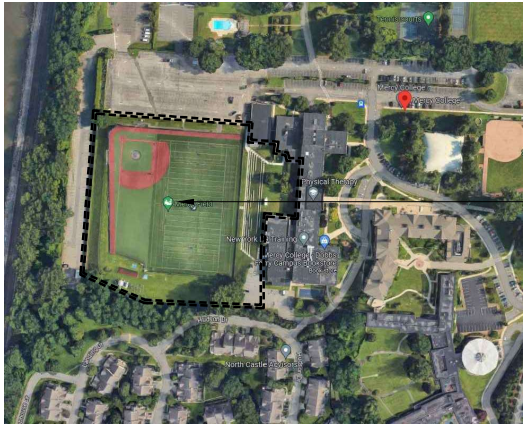

SITE PLAN
N.T.S.

SITE

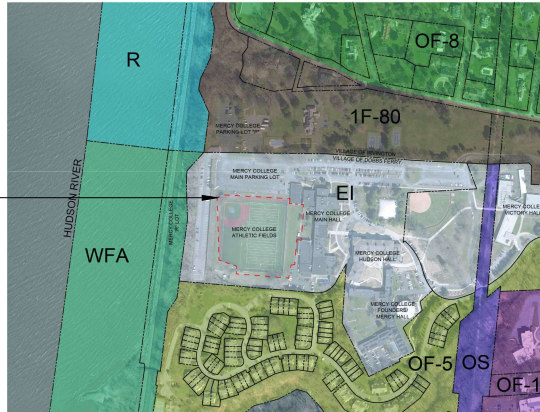

ZONING PLAN
N.T.S.

DRAWING INDEX

CS	COVER SHEET
G-1	GENERAL NOTES AND LEGEND
G-2	SPECIFICATIONS
C-001	EXISTING CONDITIONS
C-100	LAYOUT & MATERIALS PLAN
C-200	EROSION AND SEDIMENT CONTROL PLAN
C-300	CIVIL CONSTRUCTION DETAILS
C-301	CIVIL CONSTRUCTION DETAILS
E-1	ELECTRICAL NOTES, LEGEND AND FIXTURE SCHEDULE
E-2	SITE PLAN AND TRENCH DETAILS
E-3	SINGLE LINE DIAGRAMS, FLOOR PLANS, AND SCHEDULE
A-0	LOCATION PLAN
A-1	1ST BASE LINE DUGOUT
A-2	1ST BASE LINE DUGOUT
A-3	3RD BASE LINE DUGOUT
A-4	3RD BASE LINE DUGOUT
A-5	NETTING ELEVATION AND LAYOUT
A-6	NETTING ELEVATION AND LAYOUT
A-7	SCOREBOARD ELEVATION, POLE MOUNTED SPEAKER DETAIL AND SIGN PANEL

MERCY UNIVERSITY - ATHLETIC FIELD IMPROVEMENTS

PLANNING BOARD SUBMISSION

AUGUST 23, 2023

TAX MAP PARCEL ID 3.40-4-21
555 Broadway, Dobbs Ferry, NY 10522

Clarke Caton Hintz ● ● ■



MERCY UNIVERSITY PROJECT #: DF2301
CCH PROJECT #: 2306

SITE ELECTRIC:

ENVIRONMENTAL DESIGN & RESEARCH
LANDSCAPE ARCHITECTURE
ENGINEERING & ENVIRONMENTAL
SERVICES, D.P.D.
12 WATER STREET
SUITE 202
WHITE PLAINS, NEW YORK 10601
914-741-1290

SITE / CIVIL

WOODARD & CURRAN
ENGINEERING AND GEOLOGICAL
SERVICES, PA PC
800 WESTCHESTER AVENUE
SUITE N507
RYE BROOK, NEW YORK 10573
914-448-2266

STRUCTURE


HARRISON-HAMNETT, P.C.
40 KNOWLES ST.
PENNINGTON, NJ 08534
609-818-1808

Planning
Architecture
Landscape Architecture
Historic Preservation

Drawings Copyright © 2023 Clarke Caton Hintz, PC

1000 Barrack Street
Trenton, NJ 08608
tel: (609) 883-5383
fax: (609) 883-4044
www.clarkecatonhintz.com

[illegible]

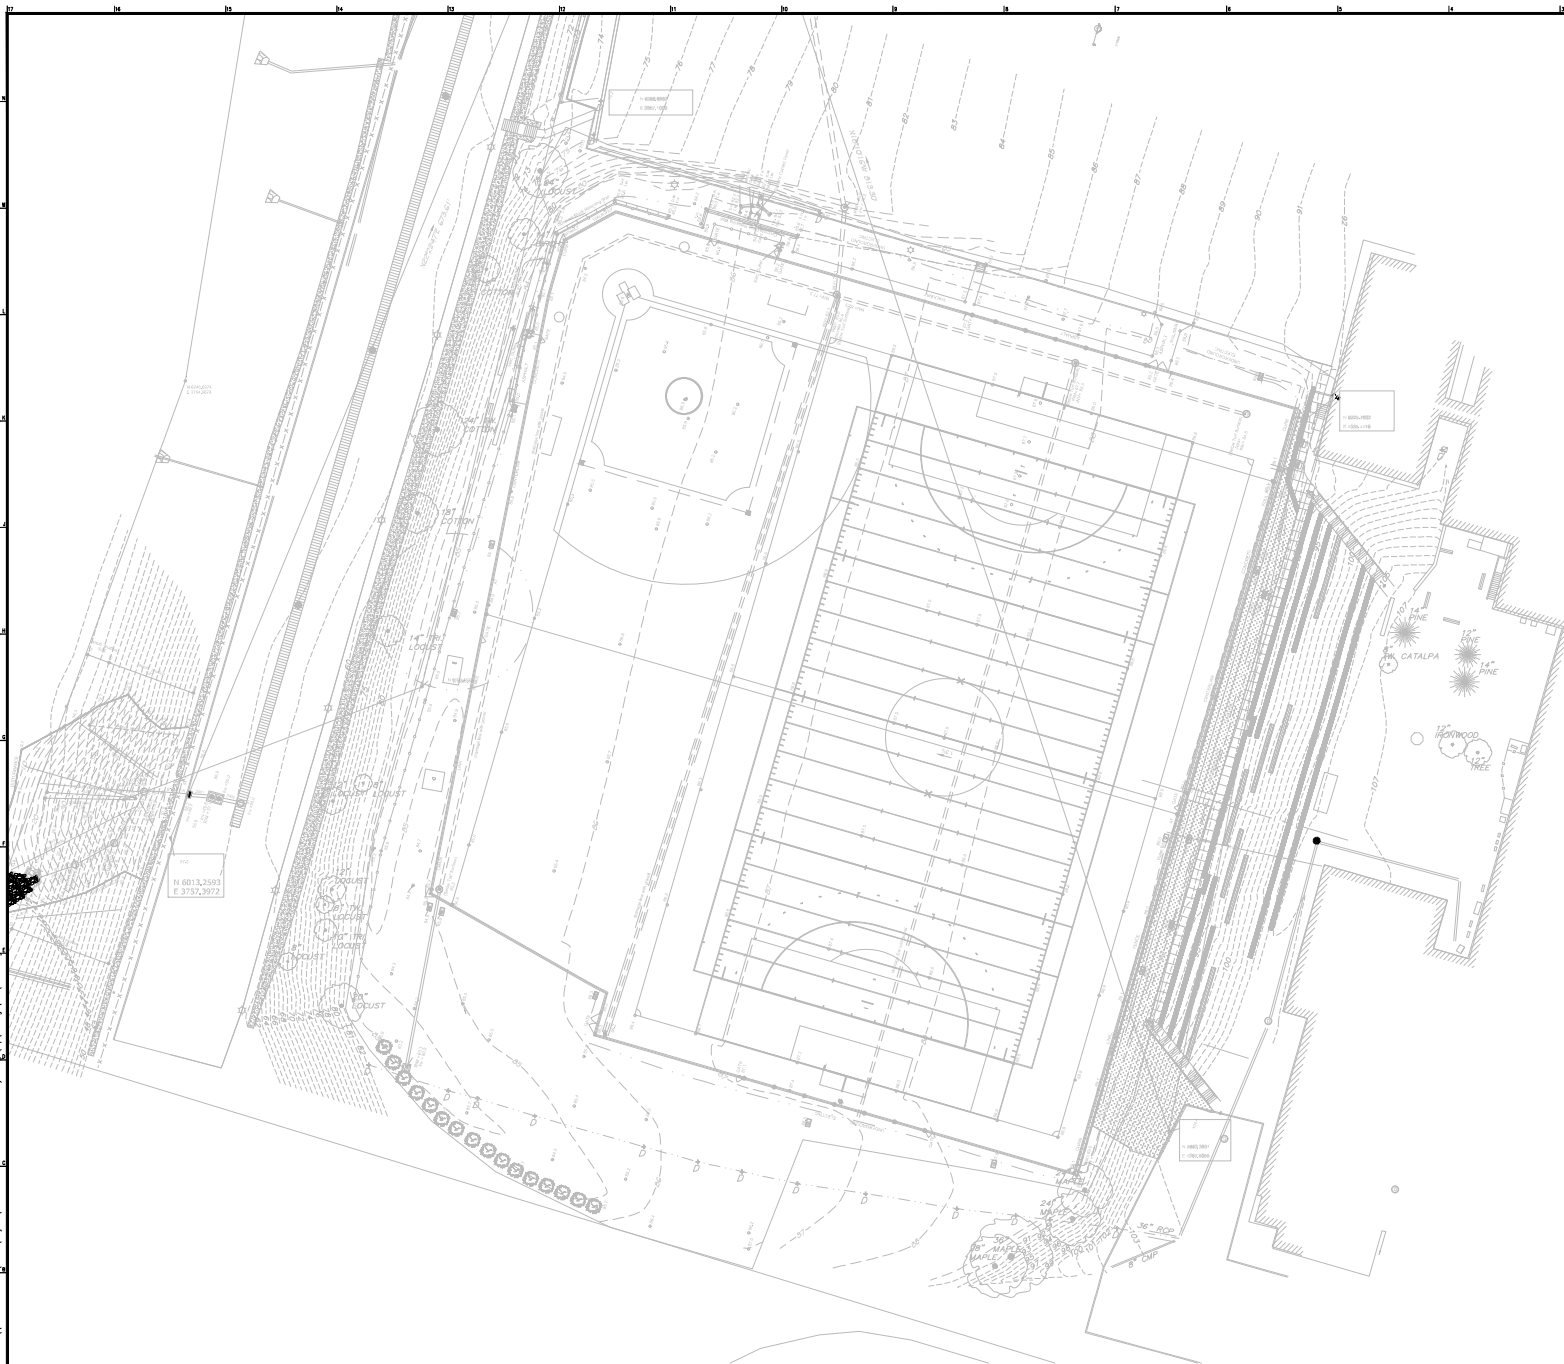

Clarke Caton Hintz ● ● ●
Architects
Planning
Landscapes Architects
Two Penn Plaza
Tenet, NJ 07030
Tel: 908-833-0500
Fax: 908-833-2011
www.clarkecatonhintz.com

1
2
3
840
84

MEXICO UNIVERSITY
 505 BROADWAY
 DOVER FERRY, NY 10522
 914-434-7800

STRUCTURE
HARRISON-HAMNETT, P.C.
40 KNOXES ST.
PENNINGTON, NJ 08534

SITE ELECTRIC:
ENVIRONMENTAL DESIGN & RESEARCH
LANDSCAPE ARCHITECTURE
ENGINEERING & ENVIRONMENTAL
SERVICES, D.P.O.
12 WATER STREET
SUITE 202
WHITE PLAINS, NEW YORK 10601
914-741-1290

SITE / CNL
WOODWARD & CURRAN
ENGINEERING AND GEOLOGICAL
SERVICES, P.A. PC
800 WESTCHESTER AVENUE
SUITE N507
RYE BROOK, NEW YORK 10573
914-448-2266

SUBMISSIONS		
NO.	DATE	DESCRIPTION
1	05.11.23	PLANNING BOARD SUB.
2	08.23.23	OWNER'S NAME UPDATE
REVISIONS		



MERCY UNIVERSITY
ATHLETIC FIELD
IMPROVEMENTS

555 BROADWAY DOBBS FERRY NY 10522


DATE:	08/23/202
SCALE:	1"=30'
DRAWN BY:	0
CHECKED BY:	S

SHEET TITLE:
EXISTING
CONDITIONS

DRAWING NO.:	C-001
CCH PROJECT NO:	23

ANY ALTERATION OF PLANS, SPECIFICATIONS, PLATS AND REPORTS BEARING THE SEAL OF A LICENSED PROFESSIONAL ENGINEER OR LICENSED LAND SURVEYOR IS A VIOLATION OF SECTION 7209 OF THE NEW YORK STATE EDUCATION LAW, EXCEPT AS PROVIDED FOR BY SECTION 7209, SUBSECTION

123232037104207
\\woodwardandlorenz\Users\Projects\0214818.00_Clarke Caton Hintz - Mercy College\Drawings\DWG\C-100.dwg
Number

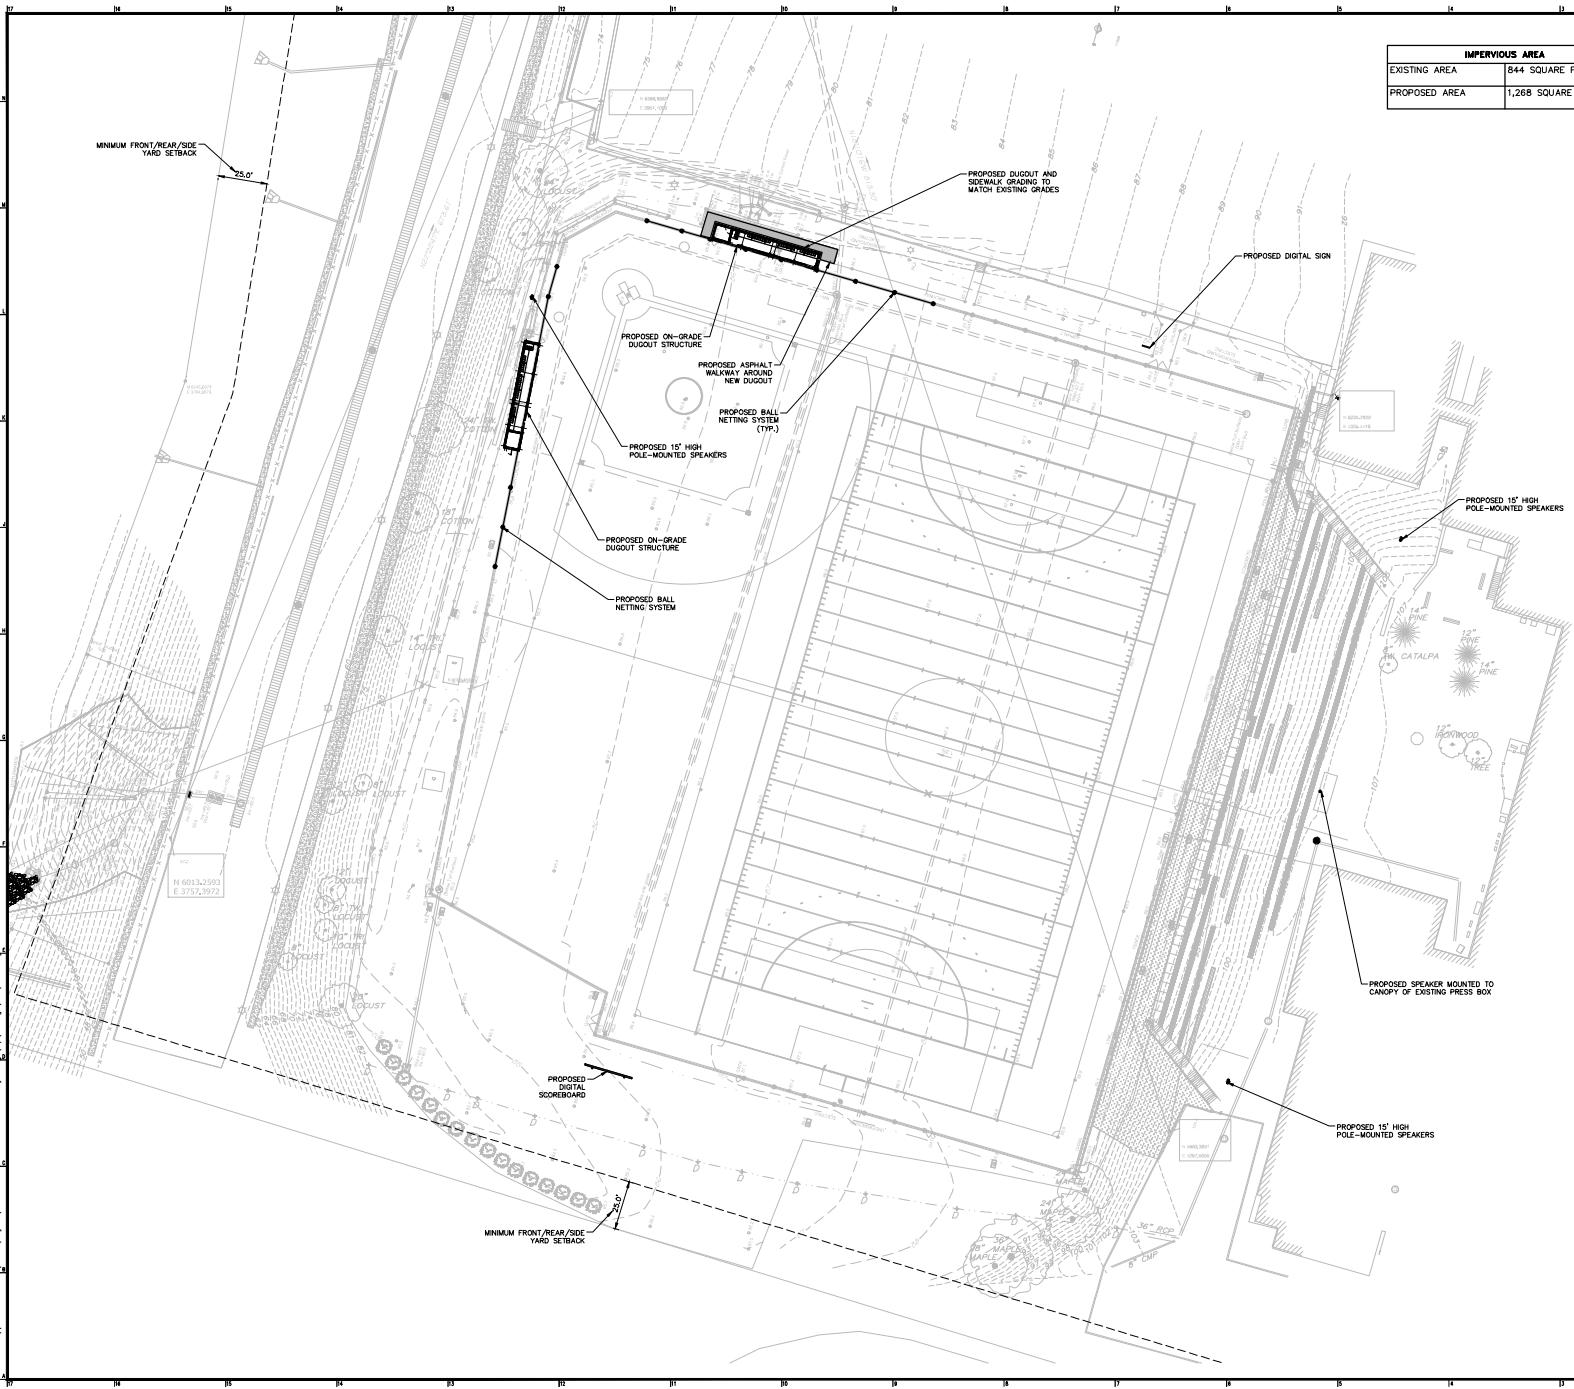

IMPERVIOUS AREA	
EXISTING AREA	844 SQUARE FEET
PROPOSED AREA	1,268 SQUARE FEET

- GRADING & DRAINAGE NOTES:
1. EXISTING DRAINAGE PATTERNS TO REMAIN UNCHANGED.
 2. PROPOSED DUGOUT AREAS TO BE FLUSH WITH GRADE. NO GUTTERS PROPOSED.

ZONING TABLE				
REQUIREMENT	EI	EXISTING	PROPOSED	
LOT SIZE	MINIMUM LOT SIZE	-	N/A	N/A
	MINIMUM LOT AREA PER DWELLING UNIT (SQUARE FEET) ¹	40,000	N/A	N/A
BUILDING HEIGHT	MAXIMUM STORIES	4	N/A	N/A
	MAXIMUM HEIGHT (FEET)	50	N/A	N/A
	MINIMUM STORIES	-	N/A	N/A
	MINIMUM HEIGHT (FEET)	-	N/A	N/A
LOT COVERAGE	MAXIMUM LOT COVERAGE BY BUILDING	50%	N/A	N/A
	MAXIMUM LOT COVERAGE BY IMPERVIOUS COVER	80%	15.26 ACRES (43.58%)	15.27 ACRES (43.60%)
SETBACKS	MINIMUM FRONT YARD SETBACK (FEET)	25	216'-1"	216'-1"
	MINIMUM REAR YARD SETBACK (FEET)	-	N/A	N/A
	MINIMUM SIDE YARD SETBACK (EACH) (FEET)	10	167'-8"	167'-8"
	MINIMUM SIDE YARD SETBACK (BOTH) (FEET)	25	167'-8"	167'-8"
	MAXIMUM SIDE YARD SETBACK (EACH) (FEET)	-	N/A	N/A

Clarke Caton Hintz

www.clarkecatonhintz.com

100 West Street
Trenton, NJ 08611
Tel: 609.392.2222
Fax: 609.392.2222

OWNER:
MERCY UNIVERSITY
100 WEST STREET
TRENTON, NJ 08611
PENNANTIAL NJ 08611
609-392-2222

STRUCTURE:
UNIVERSITY-HINTZ, P.C.
40 WEST ST
PENNANTIAL NJ 08611
609-392-2222

SITE RECORD:
ENVIRONMENTAL DESIGN & RESEARCH
ENGINEERING & ENVIRONMENTAL
SERVICES, LLC
100 WEST STREET
SUITE 200
WHITE PLAINS, NEW YORK 10611
914-438-1200

SITE / CIVIL:
RODNEY & GARDIN
ENGINEERING AND ARCHITECTS
100 WEST STREET
SUITE 200
WHITE PLAINS, NEW YORK 10611
914-438-1200

SUBMITTIONS

NO.	DATE	DESCRIPTION
1	08.11.20	PLANNING BOARD SUB.
2	08.23.23	OWNER'S NAME UPDATE

REVISIONS

NO.	DATE	DESCRIPTION

STATE OF NEW YORK
COUNTY OF MERCER
JUL 23 2023

MERCY UNIVERSITY
ATHLETIC FIELD
IMPROVEMENTS

555 BROADWAY, DOBBS FERRY, NY 10522

DATE: 08/23/2023

SCALE: 1"=30'

DRAWN BY: HAR


CHECKED BY: SL

SHEET TITLE:
LAYOUT &
MATERIALS PLAN

DRAWING NO.:
C-100

CDH PROJECT NO.: 2306

ANY ALTERATION OF PLANS, SPECIFICATIONS, PLATS AND REPORTS BEARING THE SEAL OF A LICENSED PROFESSIONAL ENGINEER OR LICENSED LAND SURVEYOR IS A VIOLATION OF SECTION 7209 OF THE NEW YORK STATE EDUCATION LAW, EXCEPT AS PROVIDED FOR BY SECTION 7209, SUBSECTION 2.

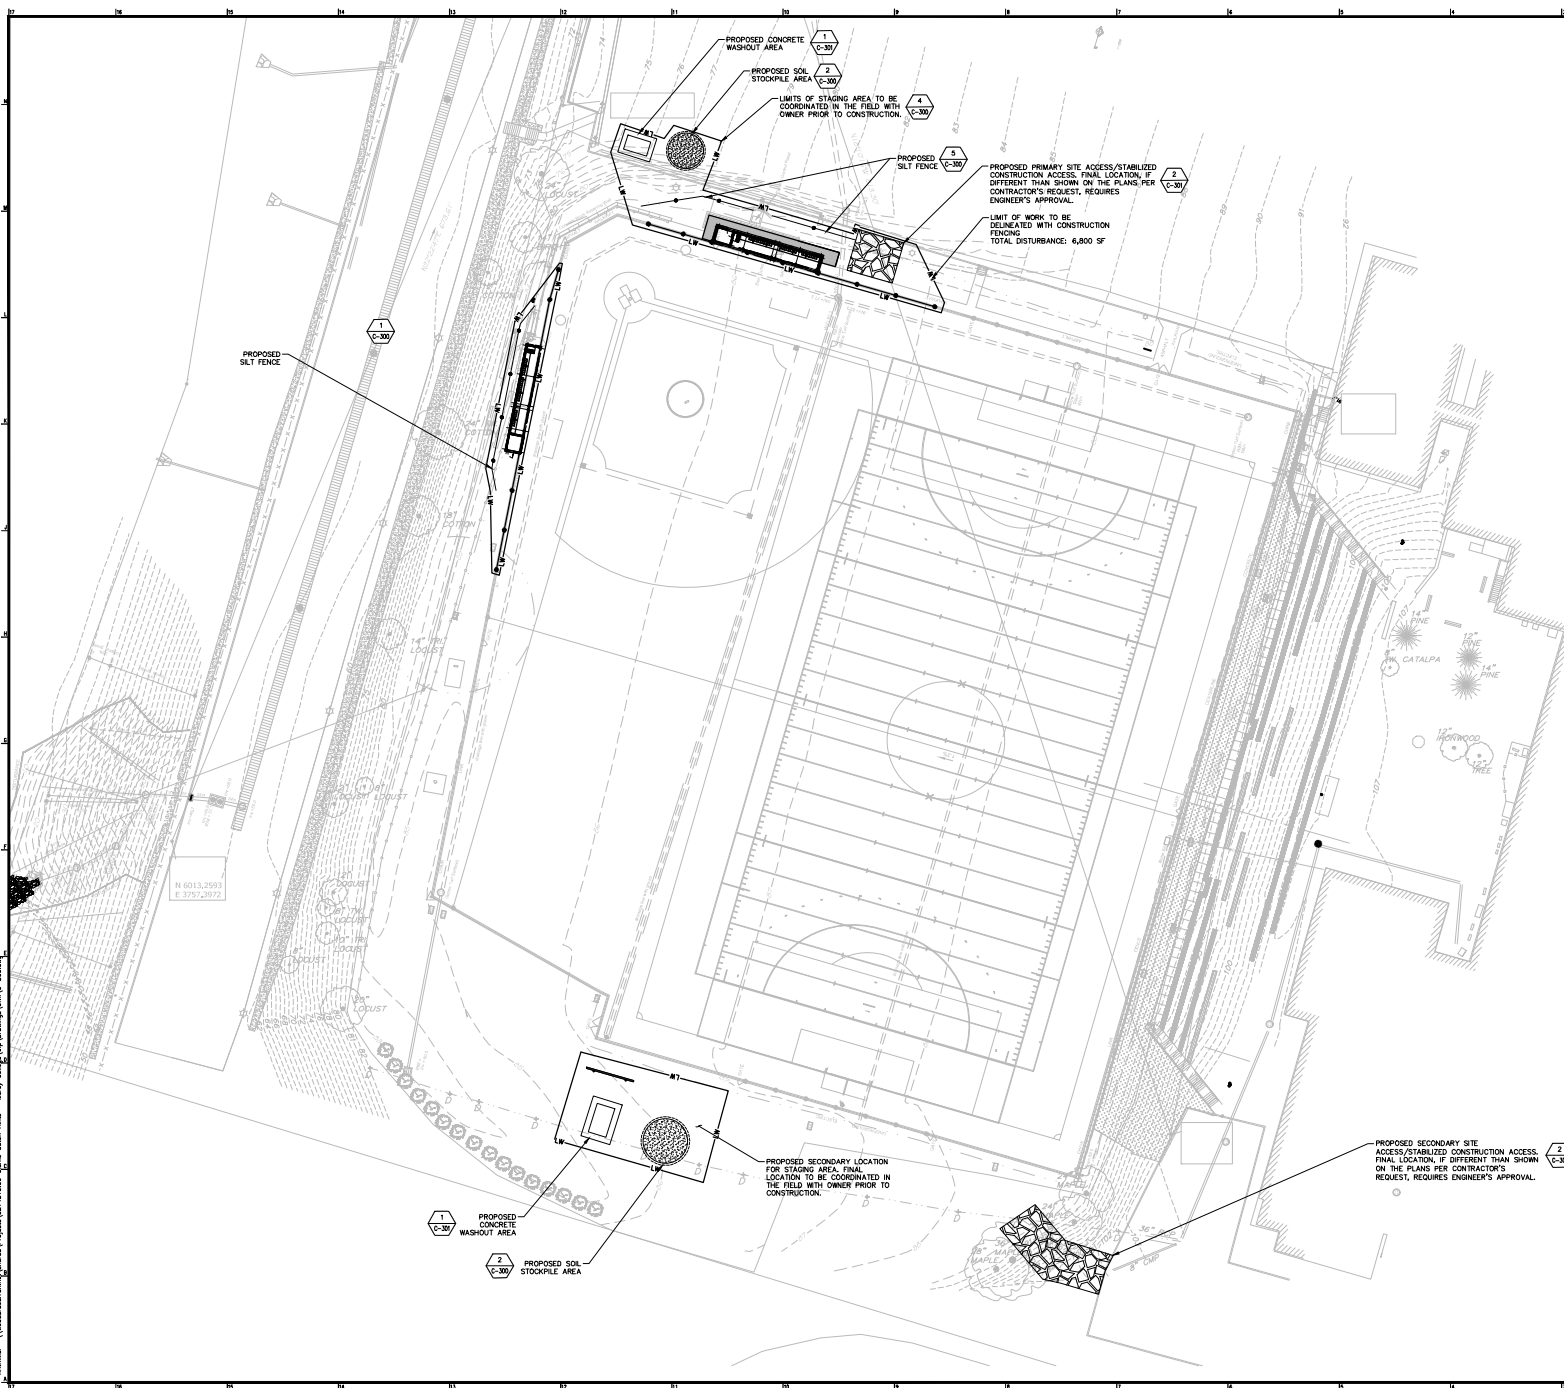

Clarke Catton Hintz

● ● ● ●

Real Estate
Investment
Services
Architectural

van Buren Street
Tomball, TX 77606
Tel: (832) 299-4646
Fax: (832) 299-0446
www.clarkecattonhintz.com


OWNER:
MORCY UNIVERSITY
500 BROADWAY
DOBBS FERRY, NY 10522
914-674-7650

STRUCTURE:
HARRISON-HAMMETT, P.E.
40 KINGSLEY ST.
FARMINGDALE, NY 06354
606-878-1808

SITE ELECTRIC:
ENVIRONMENTAL DESIGN & RESEARCH
LANDSCAPE ARCHITECTURE
ENGINEERS & ENVIRONMENTAL
SCIENTISTS, D.P.L.
12 WATER STREET
SUITE 202
WHITE PLAINS, NEW YORK 10601
914-741-1290

SITE / CIVIL:
WOODWARD & CURRIEN
ENGINEERING AND GEOLOGICAL
SERVICES, P.A.C.
800 WESTCHESTER AVENUE
FIVE BROOK, NEW YORK 10573
914-448-2266

SUBMISSIONS		
NO.	DATE	DESCRIPTION
1	05.11.23	PLANNING BOARD SUB.
2	08.23.23	OWNER'S NAME UPDATE
REVISIONS		

 

**MERCY UNIVERSITY
ATHLETIC FIELD
IMPROVEMENTS**

555 BROADWAY, DOBBS FERRY, NY 10522

DATE:	08/23/2023
SCALE:	1"=30'
DRAWN BY:	HAR
CHECKED BY:	SL

SHEET TITLE:
EROSION &
SEDIMENT
CONTROL PLAN

DRAWING NO.:	
C-200	
CCH PROJECT NO:	2306

EROSION CONTROL NOTES:


1. ALL EASO MEASURES SHALL BE INSTALLED AND MAINTAINED PER NEW YORK STATE STANDARDS AND SPECIFICATIONS FOR EROSION AND SEDIMENT CONTROL, DATED NOVEMBER 2016.
2. ANY IMPORTED TOPSOIL SHALL COMPLY WITH ALL FEDERAL, STATE, AND LOCAL REQUIREMENTS FOR QUALITY AND USE.
3. OFF-SITE DISPOSAL OF EXCESS CUT SHALL BE IN ACCORDANCE WITH ALL FEDERAL, STATE, AND LOCAL REQUIREMENTS.
4. SITE STABILIZATION (BOX UNIFORM DENSITY OF PERMANENT VEGETATION OR PERMANENT MULCH/STONE) MUST BE ACHIEVED PRIOR TO REMOVING TEMPORARY EROSION CONTROL MEASURES.
5. ALL PROPOSED EROSION AND SEDIMENT CONTROL MEASURES SHALL BE INSTALLED AS INDICATED ON THE PLANS, AND IN ACCORDANCE WITH THE NEW YORK STATE DEPARTMENT OF ENVIRONMENTAL CONSERVATION (NYSDEC) "NEW YORK STATE STANDARDS AND SPECIFICATIONS FOR EROSION AND SEDIMENT CONTROL," DATED AUGUST 2005.
6. UPON STABILIZATION OF SOIL, ANY SOIL NOT PROVIDING AN ADEQUATE ENVIRONMENT FOR PERMANENT VEGETATION SHALL BE REMOVED AND REPLACED, OR TREATED IN A MANNER THAT WILL DEM IT SUITABLE FOR VEGETATIVE GROUNDCOVER. NON-VEGETATIVE PRACTICES OF PERMANENT STABILIZATION WILL HAVE TO BE IMPLEMENTED IF REMOVAL OR TREATMENT OF SOIL WILL NOT ESTABLISH VEGETATION.
7. ADDITIONAL SOIL STABILIZATION WILL BE REQUIRED IF THERE IS THE POSSIBILITY OF WIND EROSION.
8. SEDIMENT AND DEBRIS DROPPED, WASHED, SPILLED OR TRACKED ONTO PUBLIC OR PRIVATE ROADWAYS OR OTHER HARDSCAPE SURFACES SHALL IMMEDIATELY BE REMOVED.
9. EXISTING LAWN AREAS THAT WERE DISTURBED DURING CONSTRUCTION SHALL BE RESTORED.

SCHEDULE OF TEMPORARY EROSION CONTROL MEASURES:

MEASURE	DATES FOR USE	TIMING, ACTIVITY, AND LOCATION
SILT FENCE/ CONSTRUCTION FENCE	ALL	CONTRACTOR TO INSTALL CONSTRUCTION AND SILT FENCE PRIOR TO THE START OF ANY EXCAVATION AND/OR FILLING ON THE SITE. SILT FENCE SHALL BE INSTALLED AS SHOWN ON THE EROSION AND SEDIMENT CONTROL PLAN AND DETAIL SHEETS, AND SHALL BE MAINTAINED IN EFFECTIVE OPERATING CONDITION THROUGHOUT THE CONSTRUCTION PROCESS. ALL STOCKPILES OF DIRT SHALL BE RIMMED WITH SILT FENCE IN ADDITION TO BEING TEMPORARILY SEEDED. DAMAGED SECTIONS OF SILT FENCE SHALL BE REPLACED IMMEDIATELY. FENCING SHALL BE REMOVED ONLY AFTER ALL CONSTRUCTION HAS BEEN COMPLETED AND ALL AREAS HAVE BEEN PERMANENTLY STABILIZED.
DUST CONTROL	ALL	DURING DRY WEATHER, FOR AREAS OF EXPOSED SOIL WHERE IT IS NOT FEASIBLE TO ESTABLISH TEMPORARY GROUND COVER DUE TO CONSTRUCTION OPERATIONS, THE CONTRACTOR SHALL WET AREAS WITH WATER AT LEAST TWICE A DAY IN ORDER TO CONTROL DUST. THE WETTING OF SUCH AREAS MAY BE INCREASED TO FOUR TIMES A DAY DURING PERIODS OF LITTLE RAIN AS DETERMINED BY THE ENGINEER AND/OR THE CONTRACTOR.
TEMPORARY SEEDING	ALL	CONTRACTOR SHALL TEMPORARILY SEED ALL EXPOSED AREAS OF SOIL THAT WILL NOT RECEIVE PERMANENT SURFACE TREATMENT IMMEDIATELY (WITHIN SEVEN DAYS) AND ALL PILES OF DIRT AND SOIL STOCKPILES. GRASS SEED MIX FOR EROSION AND SEDIMENT CONTROL MAY BE APPLIED BY EITHER MECHANICAL OR HYDROSEEDING METHODS. HYDROSEEDING SHALL BE PERFORMED IN ACCORDANCE WITH THE AMERICAN ASSOCIATION OF NURSERYMEN, AMERICAN STANDARD FOR NURSERY STOCK, LATEST EDITION. SEEDING RATES AND DATES OF APPLICATION SHALL BE DETERMINED AS FOLLOWS:
	APRIL 1-JULY 1 15-SEPT. 15	SEED MIXTURE: WINTER RYE APPLIED RATE: 2.6 LBS/1,000 S.F.
	APRIL 1-JULY 1	SEED MIXTURE: ANNUAL RYEGRASS APPLIED RATE: 0.9 LBS/1,000 S.F.
	MAY 15- AUGUST 15	SEED MIXTURE: ANNUAL RYEGRASS APPLIED RATE: 0.9 LBS/1,000 S.F.
	SEPTEMBER 15- OCTOBER 15	SEED MIXTURE: WINTER RYE APPLIED RATE: 2.6 LBS/1,000 S.F.
MULCH	APRIL 1 - NOVEMBER 30	ON ALL AREAS OF EXPOSED SOIL WHICH WILL NOT BE DISTURBED AGAIN WITHIN 7 DAYS, APPLY AT A RATE OF 1.5 TO 2.0 TONS PER ACRE.
WINTER MULCH	DECEMBER 1 - MARCH 31	ON ALL AREAS OF EXPOSED SOIL WHICH WILL NOT BE DISTURBED AGAIN WITHIN 7 DAYS, APPLY AT A RATE OF 3.0 TO 4.0 TONS PER ACRE. EROSION CONTROL BLANKET MAY BE USED AS A SUBSTITUTE FOR WINTER MULCH.
INSPECTIONS	UNTIL SITE IS PERMANENTLY STABILIZED	ALL EROSION AND SEDIMENT CONTROL MEASURES SHALL BE INSPECTED BY THE CONTRACTOR IMMEDIATELY AFTER EACH RAINFALL EVENT AND AT LEAST DAILY DURING PROLONGED RAINFALL. ANY REQUIRED REPAIRS SHALL BE MADE BY THE CONTRACTOR. SEDIMENT DEPOSITS SHALL BE REMOVED BY THE CONTRACTOR WHEN THEY REACH APPROXIMATELY ONE-THIRD THE HEIGHT OF THE SILT FENCE. SEDIMENTS SHALL BE DISPOSED OF IN A MANNER THAT DOES NOT RESULT IN ADDITIONAL EROSION OR POLLUTION.

SCHEDULE OF PERMANENT EROSION CONTROL MEASURES:

MEASURE	DATES FOR USE	TIMING, ACTIVITY, AND LOCATION
PAVEMENT - BASE COURSE/ FINAL COURSE	WHEN OUTSIDE AMBIENT TEMP IS ABOVE 40°F	INSTALL ONLY IN AREAS SHOWN ON THE PLAN, SHORTLY AFTER PAVEMENT BASE IS BROUGHT TO FINAL GRADE. INSTALL NEAR COMPLETION OF PROJECT.
PERMANENT SEEDING	APRIL 15 TO SEPT. 15	ON FINAL GRADE AREAS, WITHIN 10 DAYS OF FINAL GRADE PREPARATION, PREPARE TOPSOIL, FOLLOWED WITH SEEDING AND MULCH APPLICATION. PERMANENT VEGETATION MUST BE SEEDED OR SOOCEED ON ALL EXPOSED AREAS. MULCH MUST BE USED AS NECESSARY FOR PROTECTION, UNTIL SEEDING IS ESTABLISHED.
DORMANT SEEDING	SEPT. 16 TO APRIL 15	ON FINAL GRADE AREAS, WITH PREPARED TOPSOIL, APPLY SEED AT DOUBLE THE SPECIFIED RATE, ON BARE SOIL, AND FOLLOW WITH AN APPLICATION OF WINTER MULCH.

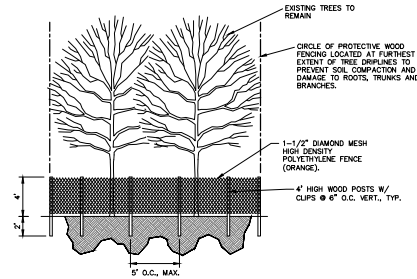


NOTES:

1. LOCATE FENCING AS SHOWN ON PLANS.
2. NO MATERIAL OR EQUIPMENT SHALL BE STORED OR STOCKPILED WITHIN THE AREA SURROUNDED BY TREE PROTECTION FENCING.
3. FENCE MUST REMAIN AND BE MAINTAINED THROUGHOUT ENTIRE BUILDING PHASES DURING WHICH CONSTRUCTION MAY AFFECT TREES.


1 TREE PROTECTION

 NOT TO SCALE



3 LAWN RESTORATION

NOT TO SCALE

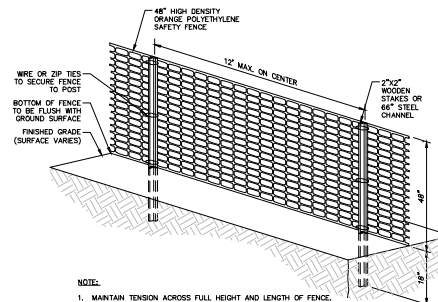


NOTE:

1. MAINTAIN TENSION ACROSS FULL HEIGHT AND LENGTH OF FENCE.
2. PROVIDE PERIODIC INSPECTION AND MAINTENANCE OF FENCE.
3. FENCE SHALL BE HIGH DENSITY ORANGE POLYETHYLENE SAFETY FENCE AS MANUFACTURED BY EROSION RUNNER® OR APPROVED EQUAL.

4 PLASTIC CONSTRUCTION SAFETY FENCE

NOT TO SCALE

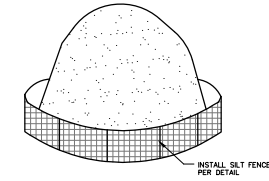


NOTES:

1. ALL STOCKPILES SHALL BE SURROUNDED BY SILT FENCING.
2. STOCKPILES SHALL HAVE A MAXIMUM 2:1 (H:V) SIDE SLOPE.
3. REPAIR/OR REPLACE ANY SILT FENCING DAMAGED DUE TO CONSTRUCTION ACTIVITIES OR STOCKPILE MITIGATION.
4. STOCKPILE SHALL BE LOCATED IN AREAS AS SHOWN ON THE DRAWINGS OR APPROVED BY THE ENGINEER.

2 TEMPORARY SOIL STOCKPILE

NOT TO SCALE

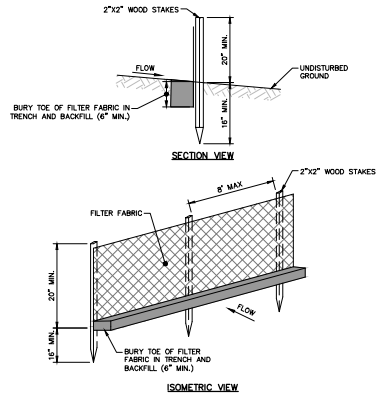

NOTES:

1. INSTALL FABRIC ON UPHILL SIDE OF WOOD STAKES.
2. SPACING BETWEEN WOOD STAKES PER MANUFACTURER'S RECOMMENDATION.
3. SILT FENCE WILL NOT BE USED IN DRAINAGE WAYS.
4. MAINTENANCE: INSPECT FOR TEARS IN THE FABRIC OR DAMAGE TO SUPPORTS. REPAIR AS NECESSARY. REMOVE ACCUMULATED SEDIMENT WHEN IT REACHES A DEPTH OF SIX-INCHES OR MORE.
5. REMOVAL: WHEN UPHILL AREAS ARE STABILIZED, THE STRUCTURE AND ANY ACCUMULATED SEDIMENT WILL BE REMOVED.

5 SILT FENCE

NOT TO SCALE

Clarke Caton Hintz
 1000 West 10th Street
 New York, NY 10011
 Tel: 212-691-1000
 Fax: 212-691-1001
 www.clarkecatonhintz.com

OWNER:
 MERCY UNIVERSITY
 300 BROADWAY
 DOBBS FERRY, NY 10322
 908-698-1000

ENGINEER:
 STRUCTURE HANDEL, P.C.
 100 WEST 10TH STREET
 NEW YORK, NY 10011
 212-691-1000

SITE DESIGN:
 ENVIRONMENTAL DESIGN & RESEARCH
 100 WEST 10TH STREET
 NEW YORK, NY 10011
 212-691-1000

SITE / ON:
 WOODS & CORMIER
 ENGINEERING AND CONSULTING
 100 WEST 10TH STREET
 NEW YORK, NY 10011
 212-691-1000

SUBMISSIONS
NO. DATE DESCRIPTION
1 08.11.13 PLANNING BOARD SUB.
2 08.23.13 OWNER'S NAME UPDATE



**MERCY UNIVERSITY
 ATHLETIC FIELD
 IMPROVEMENTS**
 555 BROADWAY, DOBBS FERRY, NY 10322


DATE: 08/23/2013
SCALE: AS SHOWN
DRAWN BY: HAR
CHECKED BY: SL

SHEET TITLE:
 CIVIL
 CONSTRUCTION
 DETAILS


DRAWING NO.:
C-300
CCH PROJECT NO.: 2306

ANY ALTERATION OF PLANS, SPECIFICATIONS, PLATS AND REPORTS BEARING THE SEAL OF A LICENSED PROFESSIONAL ENGINEER OR LICENSED LAND SURVEYOR IS A VIOLATION OF SECTION 7209 OF THE NEW YORK STATE E.O. 13636, EXCEPT AS PROVIDED FOR BY SECTION 7209, SUBSECTION 2.

123326031146201
\\woodburham\cadd\university\projects\0214818.02\01\Drawings\01\1-C-301.dwg
1/1/2021 10:46:20 AM
Clarke Caton Hintz

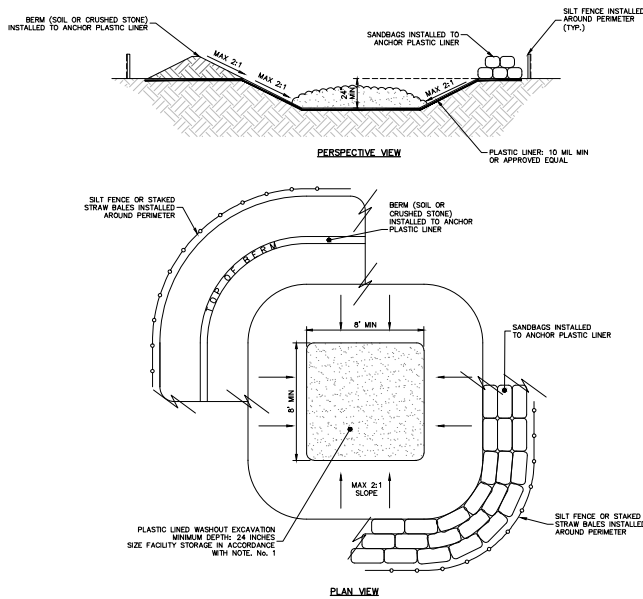

1 CONCRETE WASHOUT FACILITY
NOT TO SCALE

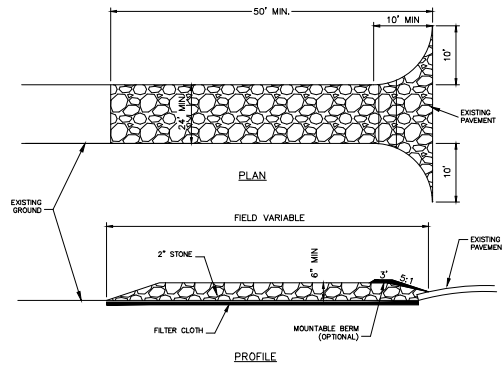

2 STABILIZED CONSTRUCTION ACCESS
NOT TO SCALE

CONSTRUCTION SPECIFICATIONS:

1. USE 2" DIAMETER STONE OR RECLAIMED/RECYCLED CONCRETE EQUIVALENT.
2. RECOMMENDED LENGTH GREATER THAN 50 FEET WHERE PRACTICAL.
3. THICKNESS NOT LESS THAN 6 INCHES.
4. 24 FOOT MINIMUM WIDTH, BUT NOT LESS THAN FULL WIDTH AT POINTS WHERE INGRESS AND EGRESS OCCUR. CONTRACTOR SHALL PROVIDE 24" WIDTH WHEREVER POSSIBLE (WITHOUT DISTURBING EXISTING STRUCTURES OR EXISTING TREES TO REMAIN).
5. FILTER CLOTH SHALL BE PLACED OVER THE ENTIRE AREA PRIOR TO PLACING OF STONE.

CONSTRUCTION SPECIFICATIONS:

6. ALL SURFACE WATER FLOWING OR DIVERTED TOWARD CONSTRUCTION ENTRANCES SHALL BE PIPED ACROSS THE ENTRANCE. IF PIPING IS IMPRACTICAL, A MOUNTABLE BERM WILL BE PERMITTED.
7. ENTRANCE SHALL BE MAINTAINED IN A CONDITION THAT WILL PREVENT TRACKING OR FLOWING OF SEDIMENT ONTO PUBLIC RIGHTS-OF-WAY. THIS MAY REQUIRE PERIODIC TOP DRESSING WITH ADDITIONAL STONE AS CONDITIONS DEMAND, AND REPAIR AND/OR CLEANOUT OF ANY MEASURES USED TO TRAP SEDIMENT. ALL SEDIMENT SPILLED, DROPPED, WASHED, OR TRACKED ONTO PUBLIC RIGHTS-OF-WAY MUST BE REMOVED IMMEDIATELY.
8. PERIODIC INSPECTION AND REQUIRED MAINTENANCE SHALL BE PROVIDED BY THE CONTRACTOR.
9. REMOVE STABILIZED CONSTRUCTION ENTRANCE PRIOR TO PLACEMENT OF BITUMINOUS CONCRETE PAVEMENT.

ANY ALTERATION OF PLANS, SPECIFICATIONS, PLATS AND REPORTS BEARING THE SEAL OF A LICENSED PROFESSIONAL ENGINEER OR LICENSED LAND SURVEYOR IS A VIOLATION OF SECTION 7209 OF THE NEW YORK STATE EDUCATION LAW, EXCEPT AS PROVIDED FOR BY SECTION 7209, SUBSECTION 2.

Clarke Caton Hintz
www.clarkecatonhintz.com
1000 Belmont Street
Trenton, NJ 08611
609-392-8800
Fax: 609-392-8801

Clarke Caton Hintz
Architects
Planning
Landscape Architecture
Drawing Copyright © 2023, Clarke Caton Hintz, P.C.

OWNER:
MERCY UNIVERSITY
555 BROADWAY
DOBBS FERRY, NY 10322
914-434-1300

STRUCTURE:
JANUSON-HANDEL, P.C.
45 HUNTERS IS.
POMONA, NJ 0824
609-878-1500

SITE ELECING:
ENVIRONMENTAL DESIGN & RESEARCH
LANDSCAPE ARCHITECTURE
ENGINEERING & ENVIRONMENTAL
SERVICES, LLC
12 WEST STREET
SUITE 200
RIVE JENY, NEW YORK 10821
914-741-1200

SITE / CIVIL:
WOODWARD CLARK
ENGINEERING AND GEOLOGICAL
SERVICES, P.C.
805 RECTOR STREET
SUITE 100
RIVE BROOK, NEW YORK 10873
914-488-0200

SUBMISSIONS	
NO.	DATE / DESCRIPTION
1	05.11.23 PLANNING BOARD SUB.
2	08.23.23 OWNER'S NAME UPDATE
REVISIONS	



MERCY UNIVERSITY
ATHLETIC FIELD
IMPROVEMENTS
555 BROADWAY, DOBBS FERRY, NY 10322

DATE: 08/23/2023
SCALE: AS SHOWN
DRAWN BY: HAR
CHECKED BY: SL

SHEET TITLE:
CIVIL
CONSTRUCTION
DETAILS

DRAWING NO.:
C-301
CCH PROJECT NO.: 2306

ABBREVIATIONS:

A/C AMP - AMPERE AMPS
AC - ALTERNATING CURRENT
AD - AMPERE
AFF - ABOVE FINISHED FLOOR
AFG - ABOVE FINISHED GRADE
AG - ABOVE GRADE
AIG - ABOVE GRADE CURRENT
ALT - ALTERNATOR
AM - AMPERE
AN - AMPERE
AO - AMPERE
AS - AMPERE SWITCH
AT - AIR SWITCH
ATC - AIR TRIP CIRCUIT
ATP - AIR TRIP RATING
ATS - AUTOMATIC TRANSFER SWITCH
AU - AMPERE
AWG - AMERICAN WIRE GAUGE
B - BREAKER
BCK - BREAKER
BS - BEARING TEMPERATURE SENSORS
C - CABLE
C/C - CABLE
CA - CABLE
CB - CIRCUIT BREAKER
CD - CONDUCTORS
CE - CIRCUIT
CLF - CURRENT LIMITING FUSE
CMP - COMPARTMENT
CM - CONDUIT
CNC - CIRCUIT NOTIFIER
CP - CONTROL PANEL
CPT - CIRCUIT PROTECT TRANSFORMER
CR - CONTROL RELAY
CT - CURRENT TRANSFORMER
CU - CONDUIT
DM - DAMPER MOTOR
EPH - DIFFERENTIAL PRESSURE
EPC - EXHAUST MOTOR
EA - EACH
EAC - EACH
ECC - ELECTRICAL CONTROL
EMH - ELECTRICAL MANHOLE
EMT - ELECTRICAL METALLIC TUBING
EN - ELECTRICAL NOTIFIER
ES - EMERGENCY SWITCH
ET - ELECTRICAL THERMAL
EUE - ELECTRICAL UNIT
EUE - EMERGENCY TIME METER
FA - FIRE ALARM
FT - FLOW THROUGH METER
FLEX - FLEXIBLE
FLA - FLOOD SWITCH
FLM - FORCE MAIN
FOSA - FLOOD-OFF-SLOW-MOTIONAL
FS - FLOW SWITCH
FSW - FLOW SWITCH
FV - FLOW VALVE
FVR - FLOW VALVE REVERSING
FVRS - FLOW VOLTAGE REVERSING
FVTS - FULL VOLTAGE TWO SPEED
GEN - GENERATOR
GPC - GENERATOR POWER CENTER
GFCI - GROUND FAULT CIRCUIT INTERRUPTER
GR - GROUND FAULT INTERRUPTER
GRND - GROUND
HDA - HAND-DAUNTAUTO SELECTOR SWITCH
HFC - HEATING AND VENTILATION
HFS - HIGH FLOW SWITCH
HNC - HIGH NOISE COUNTER
H - INDICATING LIGHT
IO - INPUT/OUTPUT
IR - INTERLOCK
IS - INTERLOCK SAFETY RELEASE
JB - JUNCTION BOX
JCC - JUNCTION COUNCIL
KCMIL - THOUSAND CIRCULAR MILS
KJ - KEY SERVICE UNIT
KL - KILOVOLT
KW - KILOWATT
L - LIGHT
LC - LIGHTING CIRCUIT
LO - LOCKOUT
LO - LOCKOUT
L - LIMIT SWITCH
M - MILLIAMPS
MAC - MAGNETIC
M - MAXIMUM

MCC - MOTOR CONTROL CENTER
 MDC - MOTOR CIRCUIT PROTECTOR
 MDS - MINE CASE SWITCH
 T-THERMAL ONLY
 M-METRIC ONLY
 AUTO-AUTOMATIC ONLY
 MDM - MINIMUM DISTRIBUTION PANEL
 MN - MANUFACTURER
 MN - MINIMUM
 MNL - MINIMUM LOSS ONLY
 MMS - MANUAL MOTOR STARTER
 MMS - MOTOR STARTING SWITCH
 MTS - MOTOR TAPPING REEL
 MWTS - MOTOR WINDING TEMPERATURE SENSOR
 MW - MOTOR WINDING TEMPERATURE PROTECTION
 NC - NORMALLY CLOSED
 NC - NORMALLY CLOSED
 NMO - NAGARAH MOWAH POWER
 NO - NORMALLY OPEN
 NP - NAMEPLATE
 NYSED - NEW YORK STATE ELECTRIC & GAS
 NY - NEW YORK STATE
 OHL - OVERHEAD TELEPHONE
 OVL - OVERLOAD RELAY
 # - PHASE
 P - PULL
 P - PUSHBUTTON
 PBL - PULLEY BOX
 PNL - PULL FITTING
 PNL - PROGRAMMABLE LOGIC CONTROLLER
 PNL - PULLING
 PCT - PRESSURE TRANSDUCER
 PR - PAIR
 PR - PRESSURE SWITCH
 PR - PRESSURE TRANSFORMER
 RCR - REMOVE & REPLACE
 RCR - RECEPTACLE
 RSS - REEDED GALVANIZED STEEL CONDUIT
 RS - REMOTE OPERATING STATION
 RS - REMOTE TERMINAL
 RTU - REMOTE TERMINAL UNIT
 SA - SURGE ARRESTOR
 SC - SECONDARY
 SEC - SECOND
 SEL - SELECTOR
 SEL - SELECTOR SWITCH
 SHLD - SHIELDED
 SL - STOP/LOCKOUT SWITCH
 SNL - SHIELDED NEUTRAL
 SS - STAINLESS STEEL
 SV - SINGLE VOLTAGE REDUCED VOLTAGE STARTER
 SSW - SAFETY SWITCH
 SPS - STOP/START PUSH BUTTON
 STR - STRANGED
 SV - SOLENOID VALVE
 SW - SWITCH
 SW - SWITCHING DUTY
 SW - SEALWATER SOLENOID VALVE
 TD - TIME DELAY
 TDR - TIME DELAY RELAY
 TERM - TERMINAL
 TMR - TIMER
 TR.SW - TRANSFER SWITCH
 TR - TRIMMERS/TIMES
 TRT - TERTIARY PHOSPHOROUS REMOVAL
 TS - TORQUE SWITCH
 TS - TORQUE SWITCH
 TST - TIGHTENED SHIELD PAIR
 TST - TORQUE SWITCH
 UG - UNDERGROUND
 UG/E - UNDERGROUND ELECTRIC
 UG - UNDERGROUND TELEPHONE
 UNL - UNDERGROUND
 UPS - UNINTERRUPTIBLE POWER SUPPLY
 VA - VOLTAGE
 VFD - VARIABLE FREQUENCY DRIVE
 VM - VOLTMETER
 VM - VOLTMETER SWITCH
 VSC - VARIABLE SPEED CONTROL
 VSB - VIBRATION SENSOR
 VM - WITH
 VWP - WEATHER PROOF, WATER PROOF
 XPR - EXPLOSION PROOF
 2SW - 2 SPEED, 1 WINDING
 2SW - 2 SPEED, 2 WINDING
 XTR - TRANSFORMER

THE CONTRACTOR SHALL COMPLY WITH AND BE INSTALLED IN ACCORDANCE WITH THE BUILDING CODE OF THE STATE OF TEXAS AND ALL CODES LOCAL OR OTHERWISE APPLICABLE TO THE PROJECT OVER THE ENTIRE PROJECT.

THE WORKS PROVIDE OR INSTALL, SINGLE OR IN COMBINATION SHALL MEAN FURNISH AND INSTALL.

THE CONTRACTOR SHALL PROVIDE ALL CUTTING AND PATCHING AS REQUIRED FOR THE INSTALLATION OF HIS WORK.

THIS CONTRACTOR SHALL BE RESPONSIBLE FOR THE PROTECTION OF HIS WORK AND THE PROPERTY OF THE OWNER. INCLUDING PROTECTION OF BUILDING OCCUPANTS, PUBLIC, AND PERSONNEL. PROVIDE APPROPRIATE BARRIERS TO PREVENT GROUND OR FALL HAZARDS.

NO SYSTEM SHALL BE SHUT DOWN WITHOUT PERMISSION OF THE OWNER/OWNER. ADEQUATE NOTICE SHALL BE GIVEN TO THE OWNER/OWNER. WHEN SYSTEM SHUTDOWN INVOLVES A TEMPORARY DISRUPTION TO SERVICES,

ANY DISRUPTION IN SERVICES SHALL BE KEPT TO A MINIMUM AND SHALL NOT BE MORE THAN 24 HOURS WITHOUT RECEIVING PRIOR WRITTEN APPROVAL OF THE OWNER/OWNER.

ALL WORK SHALL BE COORDINATED WITH THE OWNER AND ALL TRADES RELATED TO THE PROJECT.

THE CONTRACTOR SHALL TURN OVER TO THE OWNER AT THE COMPLETION OF ALL WORK, THREE COPIES OF BOUND FORM OF OPERATING, MAINTENANCE AND INSTRUCTIONS TO BE PROVIDED TO THE OWNER. ALL EQUIPMENT BROCHURES, PFDNO AND WIRING DIAGRAMS, DRAWINGS TO BE PROVIDED TO THE CONTRACTOR AND SHUTDOWN PROCEDURES OF ALL NEWLY INSTALLED EQUIPMENT.

THE CONTRACTOR SHALL FILE PLANS WITH GOVERNING AUTHORITIES HAVING JURISDICTION OVER HIS WORK. THE CONTRACTOR SHALL BE RESPONSIBLE FOR THE INSTALLATION OF HIS WORK. ALL WORK TO BE INSTALLED SHALL BE PART OF HIS WORK.

THE CONTRACTOR SHALL GUARANTEE ALL MATERIAL AND WORK INSTALLED TO BE FREE FROM DEFECTS IN MATERIAL AND WORKmanship FOR A PERIOD OF ONE (1) YEAR AFTER THE COMPLETION OF THE PROJECT. IN THE EVENT THE ENGINEER AND OWNER, THE CONTRACTOR SHALL SUBMIT A WRITING TO THE OWNER STATING SAME.

THE CONTRACTOR SHALL INDEMNIFY THE OWNER, HIS REPRESENTATIVES AND ENGINEER FROM ANY CLAIMS OR SUITS RESULTING IN NEGLIGENCE ON THE PART OF THE CONTRACTOR AND FOR FAILING TO EXECUTE HIS WORK IN ACCORDANCE WITH THE CONTRACT DOCUMENTS.

THE CONTRACTOR SHALL PROVIDE ALL BRIGGING, HOISTING AND SCAFFOLDING AS REQUIRED FOR THE INSTALLATION OF HIS WORK.

ALL WORK SHALL BE PERFORMED BY LICENSED CONTRACTORS AND WORKMAN EXPERIENCED IN THE TRADE. THE CONTRACTOR SHALL BE SUPERVISED AT ALL TIMES AND WORKMANSHIP SHALL BE FIRST CLASS IN ALL RESPECTS.

ANY VARIATION OR CHANGE IN DESIGN SHALL NOT BE MADE WITHOUT WRITTEN APPROVAL OF THE ENGINEER OR THE OWNER/OWNER. ANY WORK INSTALLED WITHOUT PRIOR APPROVAL OF THE ENGINEER OR OWNER/OWNER ON FOUND TO DEFECTIVE BY WORK OWNER SHALL BE REPLACED BY THE CONTRACTOR AT HIS OWN EXPENSE.

ALL CONSTRUCTION WORK SHALL BE CONFINED TO THE AREA INDICATED ON PLANS.

ALL WORK SHALL BE PERFORMED DURING NORMAL WORKING HOURS: 8 A.M. TO 5 P.M. MONDAY THROUGH FRIDAY. ANY WORK OUTSIDE OF THESE HOURS, REPAIRS, UNLESS DIRECTED OTHERWISE BY THE OWNER/OWNER, HOWEVER, THE CONTRACTOR MAY WORK EXTRA HOURS AS NEEDED TO COMPLETE THE PROJECT. THE CONTRACTOR SHALL BE RESPONSIBLE FOR THE PAYMENT OF ANY ADDITIONAL COST TO OWNER, AS LONG AS THE OWNER/OWNER HAS BEEN PROVIDED THE NOTIFICATION OF THE EXTRA WORK.

CUTTING & REPAIR OF CURB, SIDEWALK OR GROUND, ETC. SHALL MATCH EXISTING SURROUNDING AREA IN ALL RESPECTS. WORK SHALL BE LEFT CLEAN AND FREE OF ALL DEBRIS. ALL EXISTING CURB, SIDEWALK, DRIVEWAY AND RUBBER SHALL BE REMOVED FROM PREMISES DUE TO A LEGAL AND APPROVED MANNER.

THE CONTRACTOR SHALL MAINTAIN ON THE JOB SITE A SET OF SHOP DRAWINGS WITH ANY DEVIATIONS FROM THE ORIGINAL DESIGN SHALL BE NOTED UPON. THE CONTRACTOR SHALL MAINTAIN A SET OF SHOP DRAWINGS TO BE TURN OVER TO THE OWNER/ENGINEER AND OWNER (1) SET OF AS-BUILT REPRODUCIBLE DRAWINGS AND (2) SET OF PRINTS INCLUDING ALL APPROVED FIELD CHANGES AND REVISIONS. THE CONTRACTOR SHALL MAINTAIN A SET OF SHOP DRAWINGS.

ALL WORK SHOWN ON ALL DRAWINGS IS TO BE PROVIDED UNLESS OTHERWISE NOTED.

ALL DOWNSTREAM DEVICES AND EQUIPMENT WHICH SHOULD BE DISCONNECTED DURING THE CONSTRUCTION SHALL BE KEPT CONNECTED AT NO COST TO THE OWNER. PROVIDE ALL CONDUIT AND WIRE AS REQUIRED.

THE CONTRACTOR SHALL SUPERVISE AND DIRECT THE WORK, AS WELL AS BE SOLELY RESPONSIBLE FOR THE CONSTRUCTION METHODS, TECHNIQUES, SEQUENCES AND THE PROGRESS OF THE PROJECT.

THE CONTRACTOR SHALL BE RESPONSIBLE FOR TAKING NECESSARY PRECAUTIONS AND SHALL PROVIDE REASONABLE PROTECTION TO PREVENT INJURY OR DAMAGE TO

SCHEDULE OF LIGHTING FIXTURES					
TYPE	LAMPS WATTS	MOUNTING	VOLTAGE	MANUFACTURER	REMARKS
	LED 18W	SURFACE MOUNT	120V	HOLOPHANE EMS	4 WET LISTED ENCLOSED AND GASKETED LED LUMINAIRE WITH LOW PROFILE POLYCARBONATE LINEAR, RIBBED FROSTED LENS 2000 LUMEN OUTPUT 90 CRI AND MEDIAN LIGHTING DISTRIBUTION, OR APPROVED EQUAL.

LEGEND	
SYMBOL	DESCRIPTION
	EXISTING EQUIPMENT, DEVICE, CONDUIT, ETC.
	EQUIPMENT, DEVICE, CONDUIT, ETC. TO BE PROVIDED
	CIRCUIT BREAKER
	PANELBOARD
	15 POLE AND SPEAKER SYSTEM
	DISCONNECT SWITCH (FRAME/FUSE)
	GROUND ROD
	CIRCUIT HOMERUN (120V) TO PANELBOARD
	CIRCUIT HOMERUN (208V/30V) TO PANELBOARD
	STAGE LUMINAIRE
	120V 10 20A QUADRUPLER RECEPTACLE
	WIRELESS ACCESS POINT

Clarke Caton Hintz ● ● ● ■
Architects
Planning
Landscapes Architecture
1000 Broadway Street
Trenton, NJ 08611
Tel: 609.392.5500
Fax: 609.392.5501
www.clarkecatonhintz.com

STRUCTURE
HARRISON-HANNETT, P.
40 KIMBLE'S ST.
PENNINGTON, NJ 08534
609-810-1800

SITE / CIVIL
WOODWARD & CLARK
ENGINEERING AND GEOLOGICAL
SERVICES, P.A. PC
800 WESTCHESTER AVENUE
WOODBURY, NEW JERSEY


REVISIONS		




555 BROADWAY, DOBBS FERRY, NY 10522

SHEET TITLE:
ELECTRICAL
NOTES, LEGEND,
AND FIXTURE
SCHEDULE


DRAWING NO.:	E-1
CCH PROJECT NO:	2306

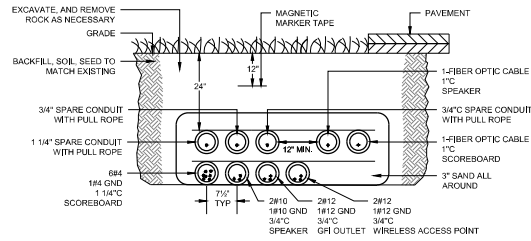


1 TRENCH DETAIL
E-2 SCALE: N.T.S.

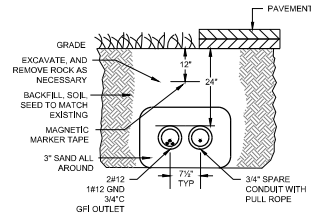


2 TRENCH DETAIL
E-2 SCALE: N.T.S.

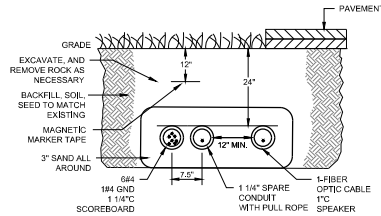


3 TRENCH DETAIL
E-2 SCALE: N.T.S.

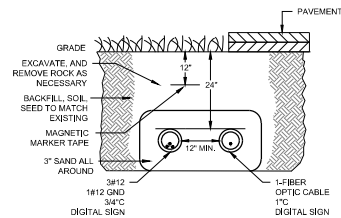


4 TRENCH DETAIL
E-2 SCALE: N.T.S.

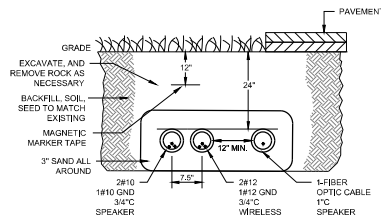

5 TRENCH DETAIL
E-2 SCALE: N.T.S.

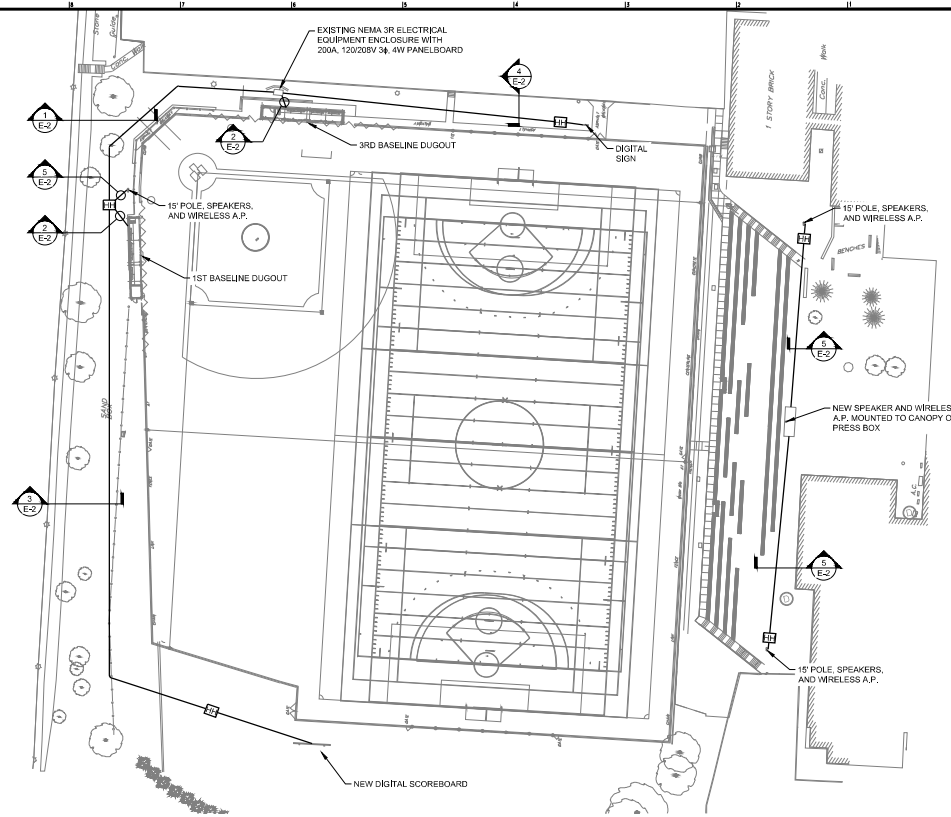

SITE PLAN
SCALE: 1" = 40'-0"

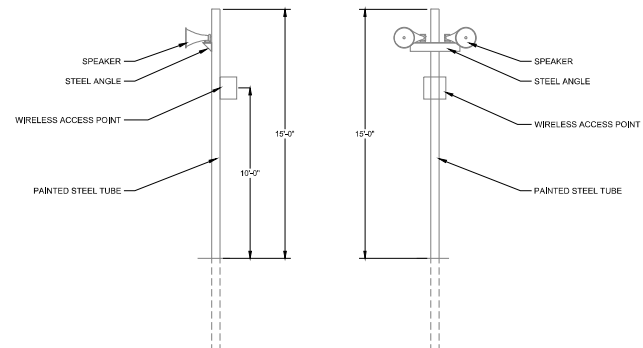

SPEAKER DETAIL
SCALE: N.T.S.



Clarke Caton Hintz
ARCHITECTS
100 BROADWAY
DOVER, NJ 07801
908-444-1000
www.clarkecatonhintz.com

OWNER:
MERCY UNIVERSITY
100 BROADWAY
DOVER, NJ 07801
908-444-1000

STRUCTURE:
JANSON-WHARTON, P.C.
400 WILSON DRIVE
PENNSACOLA, FL 32504
904-618-1000

SITE ELECTRIC:
ENVIRONMENTAL DESIGN & RESEARCH
UNIVERSITY OF MARYLAND
ENGINEERING & CONSTRUCTION
SERVICES, LLC
12 BRISTOL STREET
SUITE 200
BETHESDA, MD 20814
301-461-2411

SITE / CIVIL:
BOGARD & CURRAN
LANDSCAPE ARCHITECTS
1000 WILSON DRIVE
SUITE 100
BETHESDA, MD 20814
301-461-2411

SUBMISSIONS		
NO.	DATE	DESCRIPTION
1	08.11.23	PLANNING BOARD SUB.
2	08.23.23	OWNER'S NAME UPDATE




**MERCY UNIVERSITY
ATHLETIC FIELD
IMPROVEMENTS**
555 BROADWAY, DOVER, NJ 07801

DATE: 08/23/2023
SCALE: AS NOTED
DRAWN BY: DW
CHECKED BY: CRL


SHEET TITLE:
**SITE PLAN AND
TRENCH DETAILS**

DRAWING NO.:
E-2
CCH PROJECT NO.: 2306

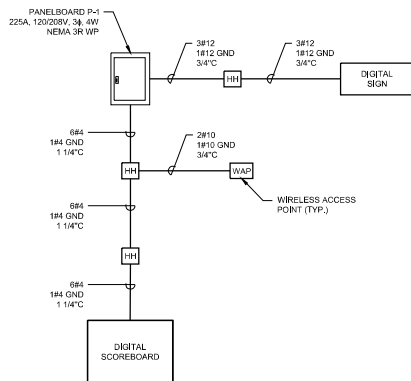

POWER SINGLE LINE


SCALE: N.T.S.

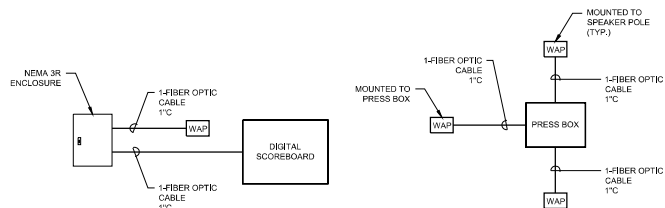

NETWORK DIAGRAM


SCALE: N.T.S.

EXISTING PANELBOARD P-1 SCHEDULE									
MAIN BUS RATINGS: 225A, 120/208V, 3Φ, 4WIRE					FED FROM: MAIN SWITCHGEAR				
MINIMUM SHORTCIRCUIT INTERRUPTION RATING: 10,000 AIC					INCOMING FEED:				
MAIN BREAKER TRIP: 225A					ENCLOSURE:				
ESTIMATED CONNECTED LOAD: X KW									
DESCRIPTION	LOAD KW	CB TRIP/POLE	CIR NO		CIR NO	CB TRIP/POLE	LOAD KW	DESCRIPTION	
A B C									
NEAR DUGOUT GFCI	0.5	20A/1P	1		2	20A/1P	0.1	NEAR DUGOUT LTG	
FAR DUGOUT GFCI	0.5	20A/1P	3		4	20A/1P	0.1	FAR DUGOUT LTG	
EXISTING LOAD	0.5	20A/1P	5		6	20A/1P	1.7	EXISTING LOAD	
EXISTING LOAD	0.5	20A/1P	7		8	20A/1P	1.7	EXISTING LOAD	
EXISTING LOAD	0.5	20A/1P	9		10	20A/1P	0.6	EXISTING LOAD	
EXISTING LOAD	1.7	20A/1P	11		12	20A/1P	0.6	EXISTING LOAD	
EXISTING LOAD	1.0	20A/1P	13		14	20A/1P	0.2	EXISTING LOAD	
EXISTING LOAD	1.0	20A/1P	15		16	20A/1P	1.4	EXISTING LOAD	
EXISTING LOAD	1.0	20A/1P	17		18	20A/1P	0.5	WIRELESS ACCESS POINT	
EXISTING LOAD	1.0	20A/1P	19		20	20A/1P		SPARE	
SCOREBOARD	8.0	50A/2P	21		22	20A/1P		SPARE	
			23		24	20A/1P		SPARE	
SCOREBOARD	8.0	50A/2P	25		26	20A/1P		SPARE	
			27		28	20A/1P		SPARE	
DIGITAL SIGN	0.5	20A/1P	29		30	20A/1P		SPARE	

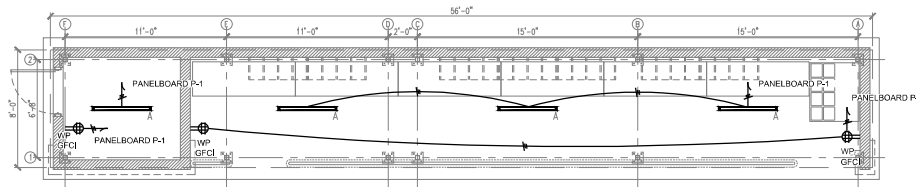

1ST BASELINE DUGOUT PLAN

SCALE: 1/4" = 1'-0"

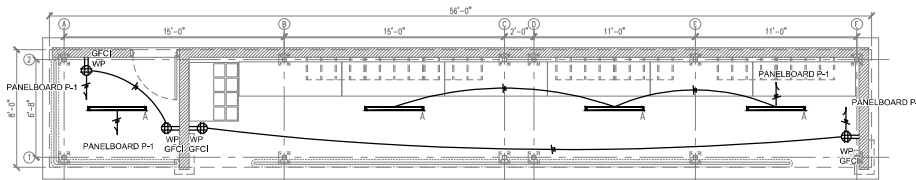

3RD BASELINE DUGOUT PLAN

SCALE: 1/4" = 1'-0"

0 2'-0" 4'-0" 6'-0" 8'-0"
SCALE: 1/4"=1'-0" AT ORIGINAL SIZE

Clarke Caton Hintz
100 Broadway
Dobbs Ferry, NY 10522
914-488-1000
www.clarkecatonhintz.com

OWNER:
MERCY UNIVERSITY
155 BROADWAY
DOBBS FERRY, NY 10522
914-488-1000

STRUCTURE:
JANSON-HANDEL, P.C.
40 WOODS RD.
POMONA, NJ 08859
800-478-1000

SITE ELECTRIC:
UNIVERSITY DESIGN & RESEARCH
UNIVERSITY ARCHITECTURE
ENGINEERING & ENVIRONMENTAL
SERVICES, LLC
12 BRISTOL STREET
SUITE 200
BRIDGE PLANK, NEW YORK 10521
914-761-1200

SITE / CIVIL:
BOGGS & CURRAN
ENGINEERING AND ARCHITECTURE
300 WOODSTOCK AVENUE
SUITE 100
P.O. BOX 100
NEW YORK, NY 10521
914-488-1000

SUBMISSIONS
NO. DATE DESCRIPTION
1 08.11.23 PLANNING BOARD SUB.
2 08.23.23 OWNER'S NAME UPDATE

REVISIONS

REVISIONS


REVISIONS

REVISIONS


REVISIONS

REVISIONS


REVISIONS

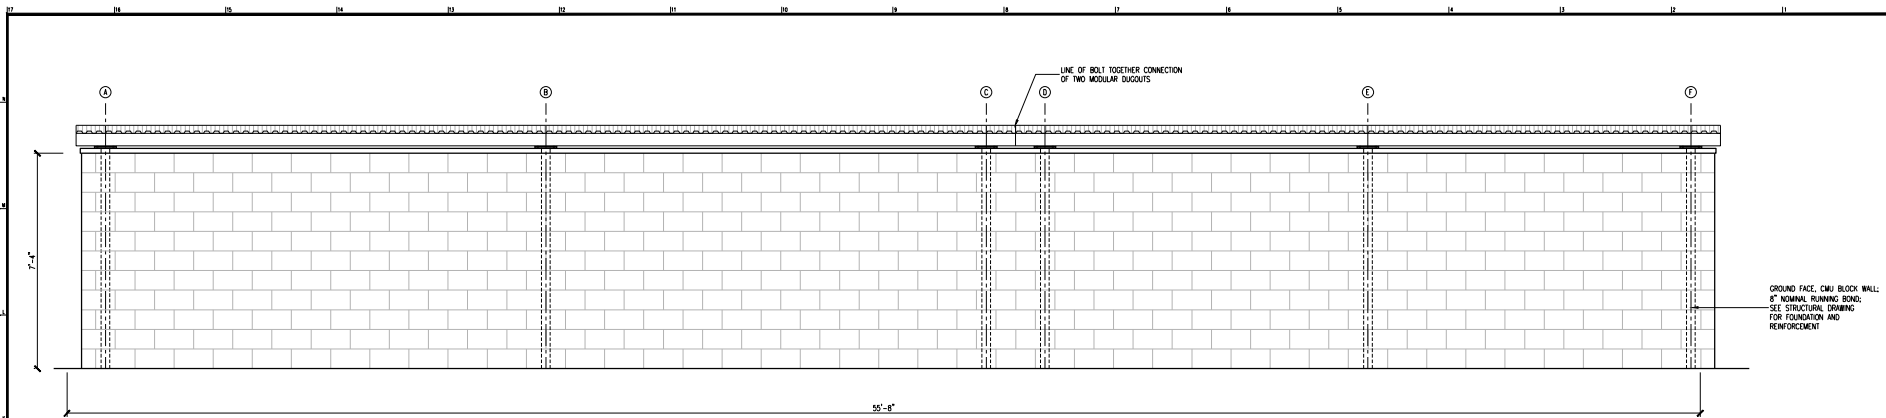

L20 1ST BASE LINE DUGOUT - ELEVATION

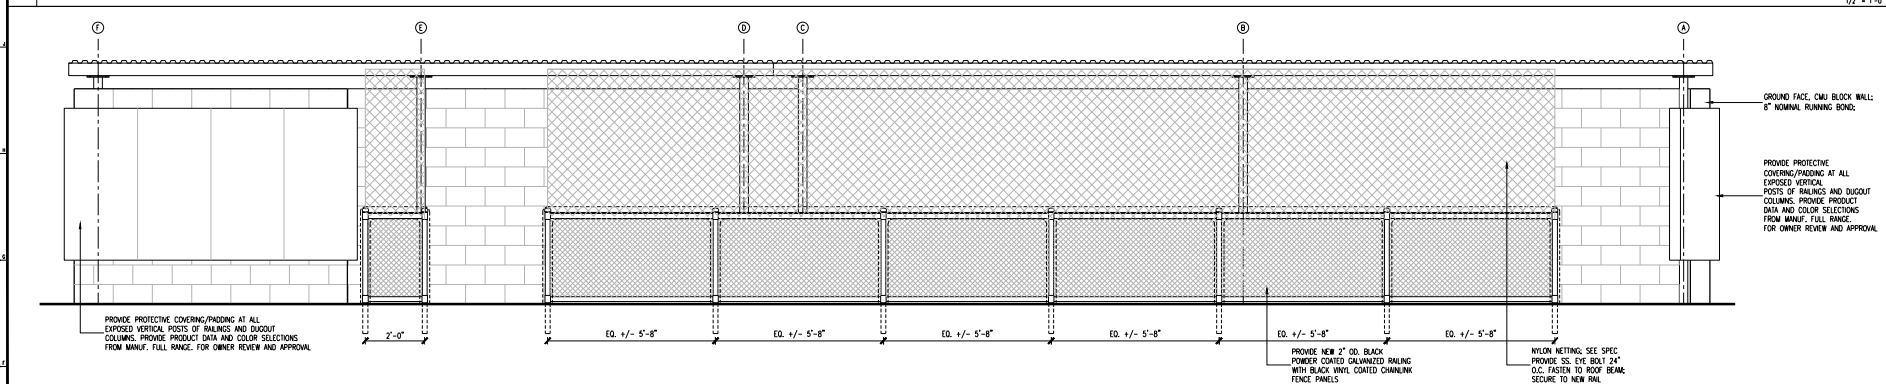

F20 1ST BASE LINE DUGOUT - FIELD ELEVATION

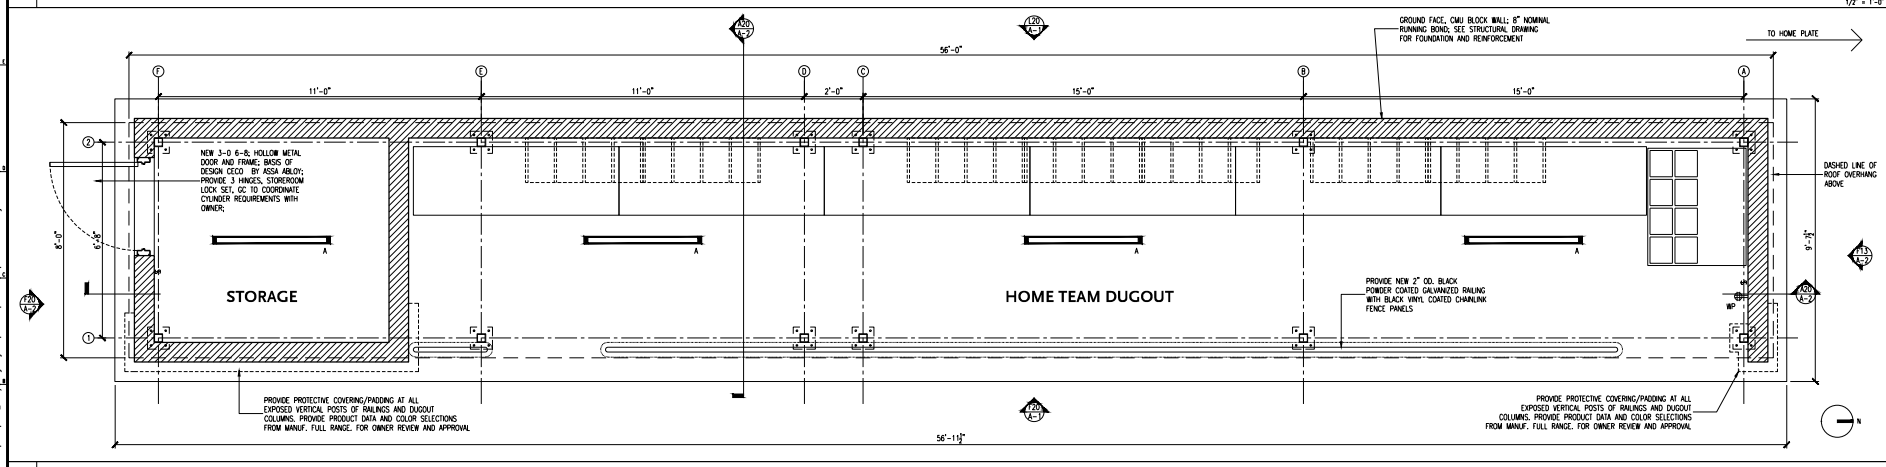

A20 1ST BASE LINE DUGOUT PLAN

Clarke Caton Hintz

1000 Belmont Street
Trenton, NJ 08611
609-441-1000
www.clarkecatonhintz.com

OWNER:
MERCY UNIVERSITY
155 BROADWAY
DOBBS FERRY, NY 10522
914-480-1000

STRUCTURE:
HARRISON-HANDELL, P.C.
40 WOODEN ST.
PENNSAULT, NJ 08854
609-639-1000

SITE ELECTRIC:
ENVIRONMENTAL DESIGN & RESEARCH
LANDSCAPE ARCHITECTURE
ENGINEERING & ENVIRONMENTAL
SERVICES, LLC
12 BRIER STREET
SUITE 200
BRIDGE PLANK, NEW YORK 10521
914-741-1200

DESIGN & CONSTRUCTION:
HARRISON-HANDELL, P.C.
40 WOODEN ST.
PENNSAULT, NJ 08854
609-639-1000

SUBMISSIONS:

NO.	DATE	DESCRIPTION
1	08.11.23	PLANNING BOARD SUB.
2	08.23.23	OWNER'S NAME UPDATE

REVISIONS:

NO.	DATE	DESCRIPTION
1	08.11.23	PLANNING BOARD SUB.
2	08.23.23	OWNER'S NAME UPDATE

REGISTERED ARCHITECT
STATE OF NEW YORK
002148


MERCY UNIVERSITY
ATHLETIC FIELD
IMPROVEMENTS
555 BROADWAY, DOBBS FERRY, NY 10522

DATE: 08/23/2023
SCALE: AS NOTED
DRAWN BY: JCC
CHECKED BY: GH

SHEET TITLE:
1ST BASE LINE DUGOUT

DRAWING NO.:
A-1

CCH PROJECT NO.: 2306

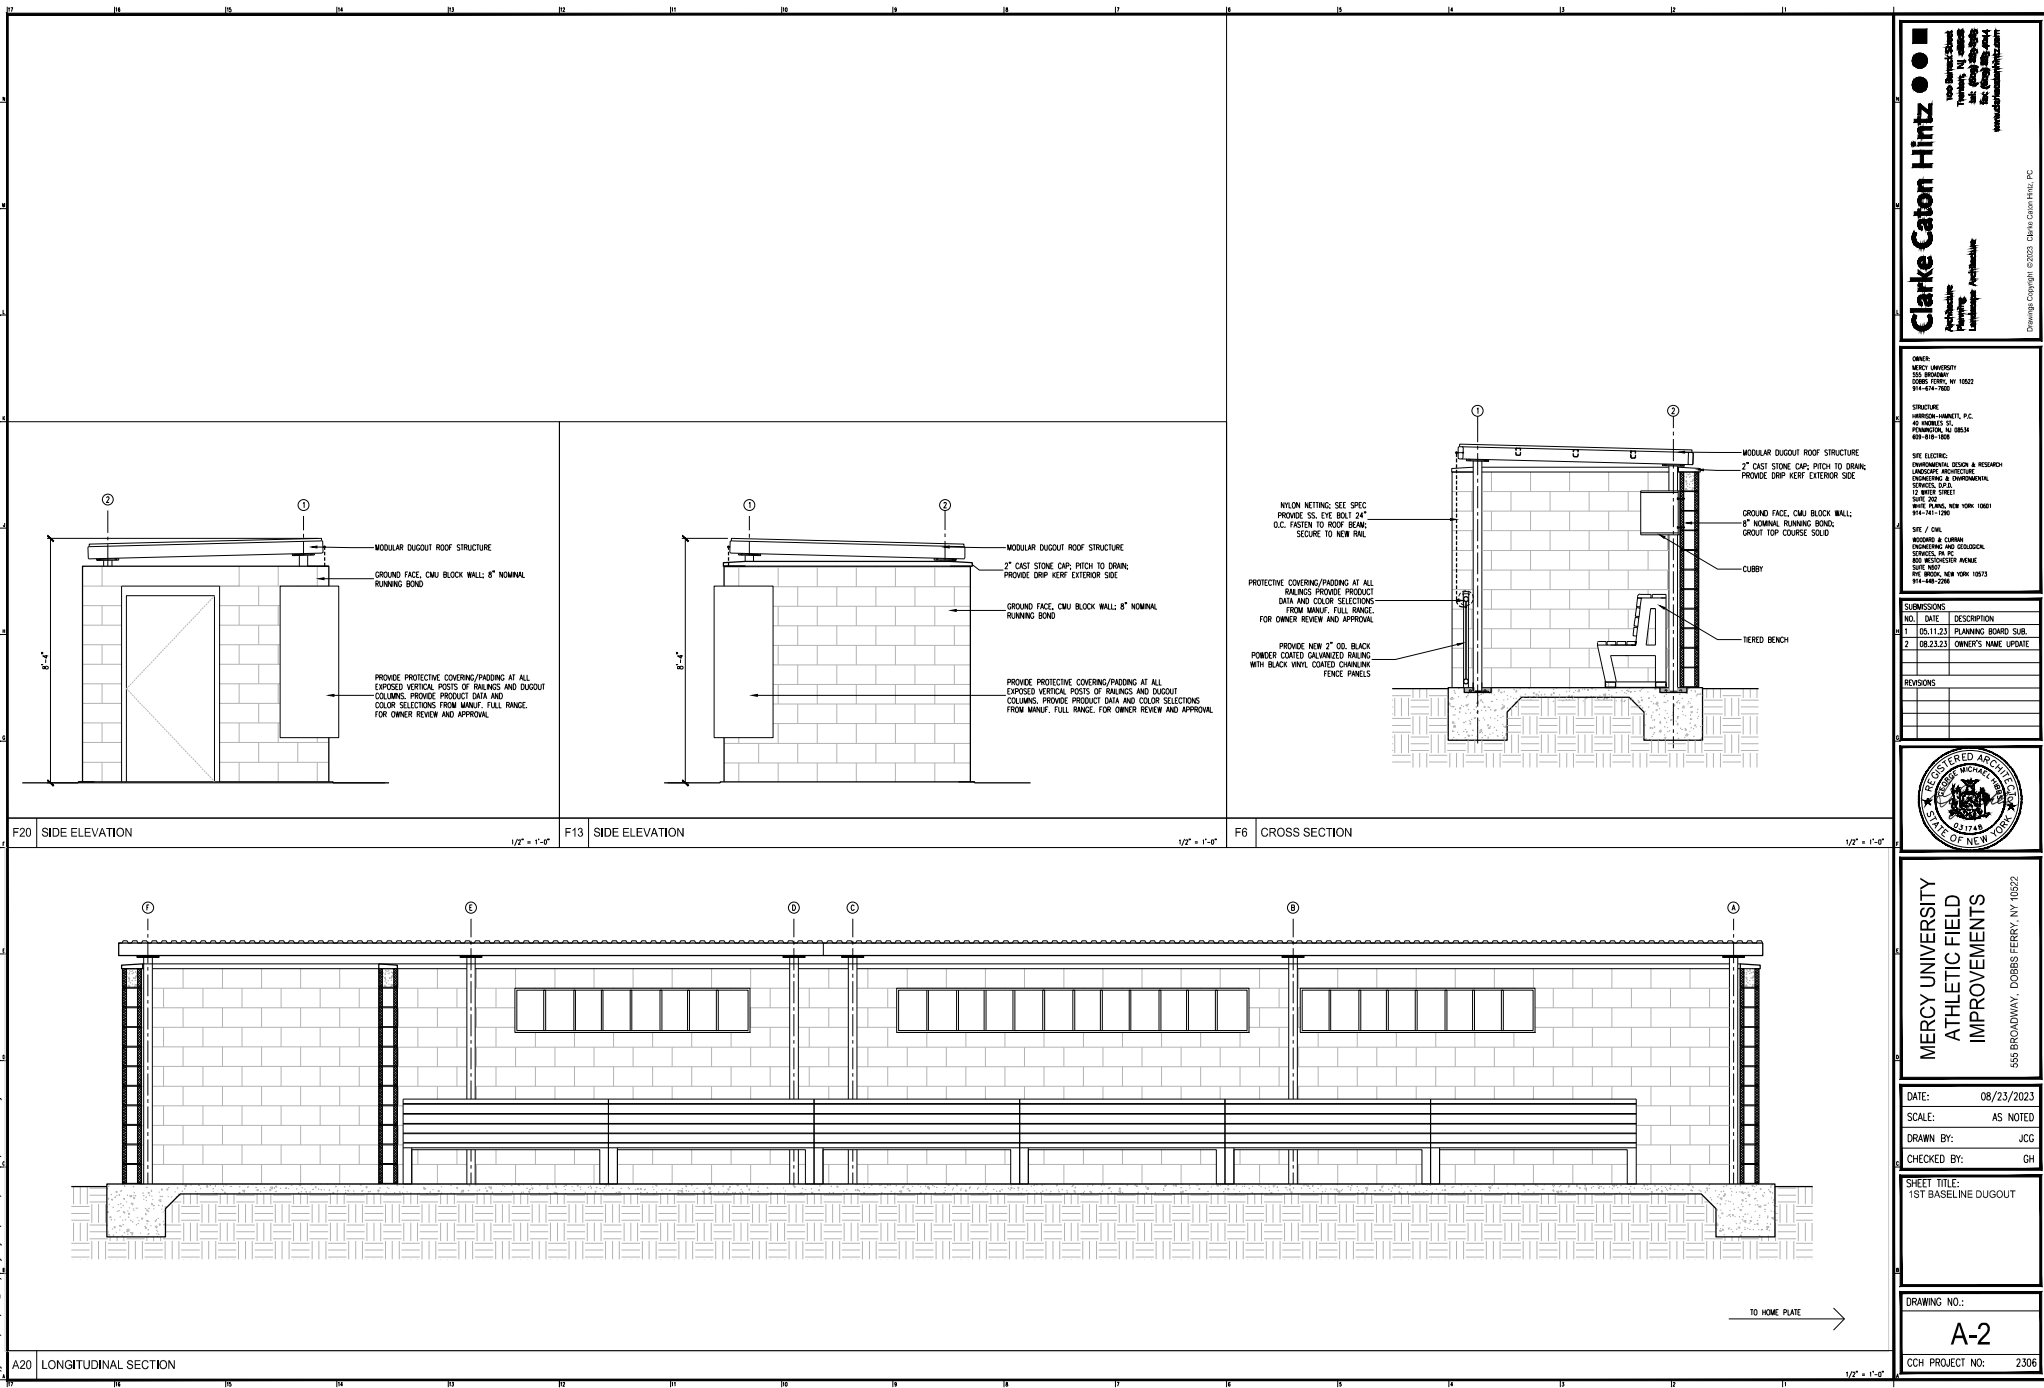

Clarke Caton Hintz

1000 Belmont Street
Trenton, NJ 08611
Tel: 609.392.8800
www.clarkecatonhintz.com

Architecture
Engineering
Landscape Architecture

Drawing Copyright ©2023, Clarke Caton Hintz, PC

OWNER:
MERCY UNIVERSITY
155 BROADWAY
DOBB'S FERRY, NJ 08522
914-424-1001

STRUCTURE:
HARRISON-HANDELL, P.C.
40 WINDY HILL
PENNSAULTA, NJ 08854
609-639-1000

SITE ELECTRIC:
ENVIRONMENTAL DESIGN & RESEARCH
LANDSCAPE ARCHITECTURE
ENGINEERING & ENVIRONMENTAL
SERVICES, LLC
12 WHEAT STREET
SUITE 200
MILLS PLAZA, NEW YORK, NY 10521
914-741-1200

SITE / CIVIL:
WOODWARD & CLARK
ENGINEERING AND DESIGN
1000 W. 10TH STREET
SUITE 100
DOBB'S FERRY, NEW YORK 10522
914-480-0200

SUBMISSIONS		
NO.	DATE	DESCRIPTION
1	05.11.23	PLANNING BOARD SUB.
2	08.23.23	OWNER'S NAME UPDATE

REVISIONS		
NO.	DATE	DESCRIPTION



**MERCY UNIVERSITY
ATHLETIC FIELD
IMPROVEMENTS**


555 BROADWAY, DOBB'S FERRY, NY 10522

DATE: 08/23/2023
SCALE: AS NOTED
DRAWN BY: JCC
CHECKED BY: GH

SHEET TITLE:
1ST BASELINE DUGOUT


DRAWING NO.:
A-2
CCH PROJECT NO.: 2306

12378923101
Project: N:\2306\2306_MercyAthleticFieldImprovements\1-0805\1-2-Sheets\A-01_A-2.dwg

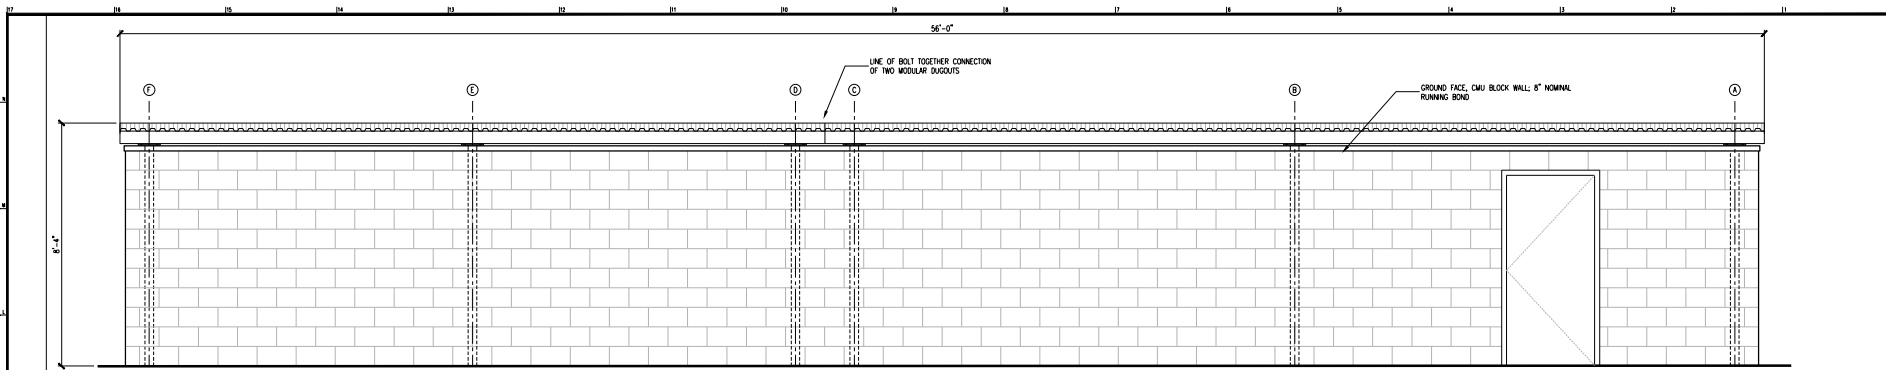


L20 3RD BASE LINE DUGOUT - ELEVATION

1/2" = 1'-0"

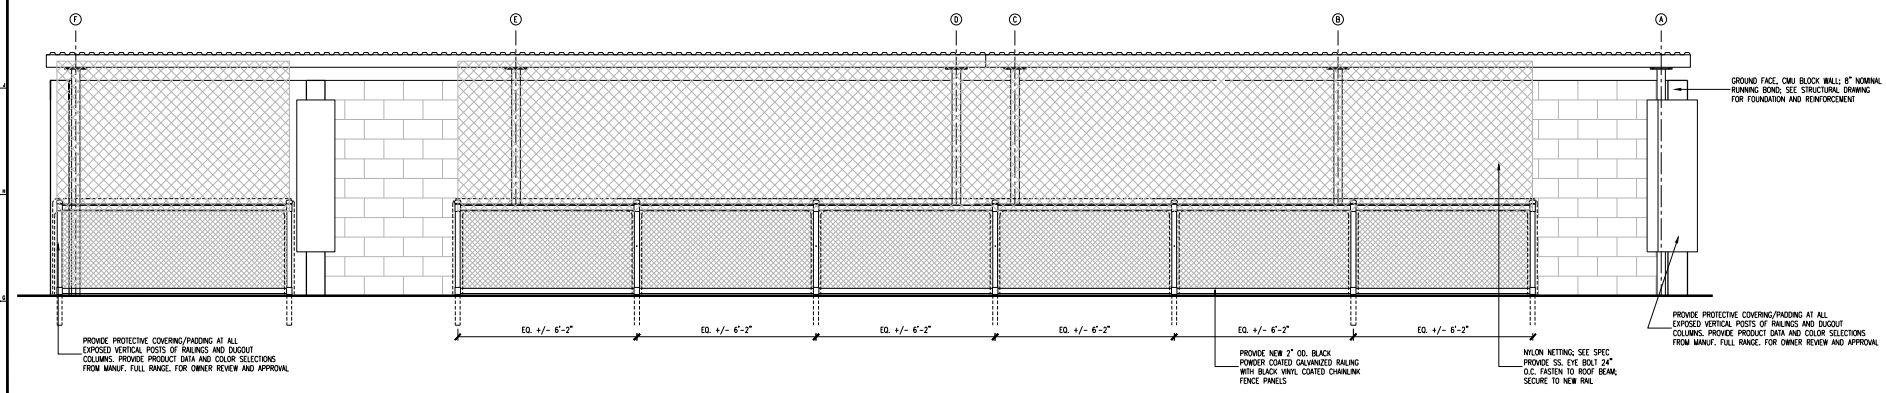

F20 3RD BASE LINE DUGOUT - FIELD ELEVATION

1/2" = 1'-0"

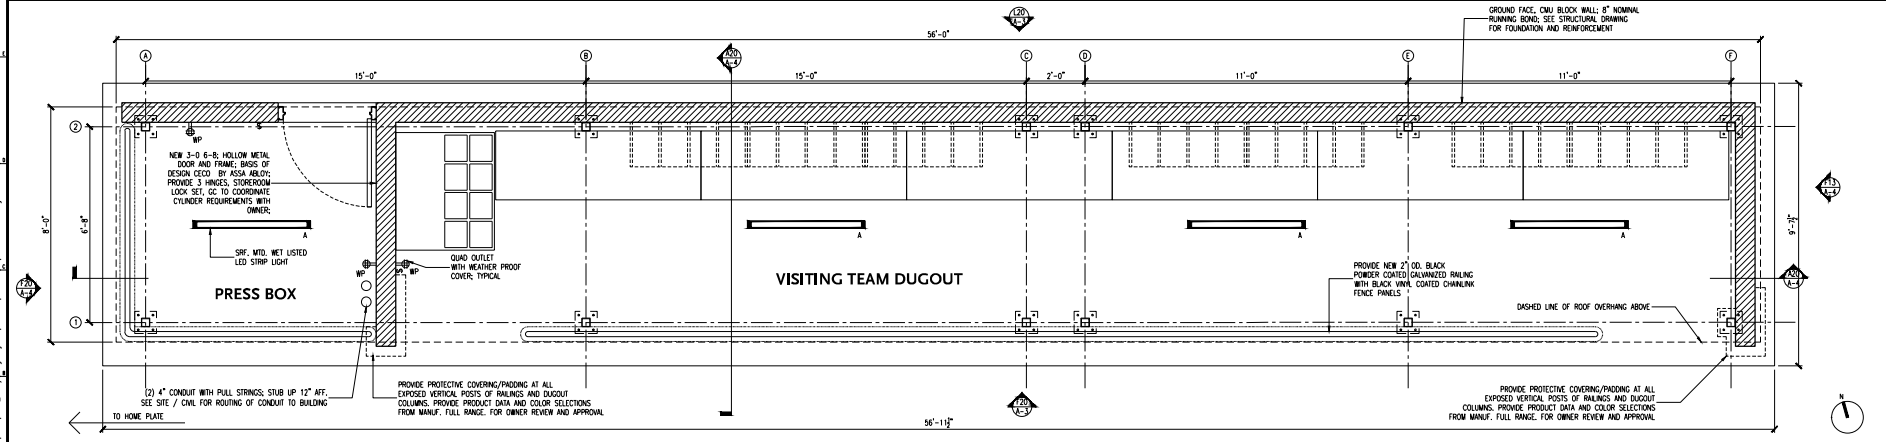

A20 3RD BASE LINE DUGOUT - PLAN

1/2" = 1'-0"

Clarke Caton Hintz

1000 West 34th Street
Trenton, NJ 08611
www.clarkecatonhintz.com

Professional Engineer
Professional Architect

Drawing Copyright ©2023, Clarke Caton Hintz, PC

OWNER:
MERCY UNIVERSITY
155 BROADWAY
DOBBS FERRY, NY 10522
914-424-7001

STRUCTURE:
HARRISON-HANDELL, P.C.
40 PARKER ST.
PENNSAULT, NJ 08854
609-639-1000

SITE ELECTRIC:
ENVIRONMENTAL DESIGN & RESEARCH
LANDSCAPE ARCHITECTURE
ENGINEERING & ENVIRONMENTAL
SERVICES, LLC
12 GREY STREET
SUITE 200
NEW PLAIN, NEW YORK 10561
914-241-1200

SITE / CIVIL:
BOGGS & CURRAN
ENGINEERING AND DESIGN
HARRISON, NJ
805 RECOVERER AVENUE
SUITE 100
PINE BROOK, NEW YORK 10573
914-480-2000

SUBMISSIONS		
NO.	DATE	DESCRIPTION
1	08.11.23	PLANNING BOARD SUB.
2	08.23.23	OWNER'S NAME UPDATE

REVISIONS	
NO.	DESCRIPTION



**MERCY UNIVERSITY
ATHLETIC FIELD
IMPROVEMENTS**


555 BROADWAY, DOBBS FERRY, NY 10522

DATE: 08/23/2023
SCALE: AS NOTED
DRAWN BY: JCC
CHECKED BY: GH

SHEET TITLE:
3RD BASE LINE DUGOUT

DRAWING NO.:
A-3
CCH PROJECT NO.: 2306

1233492306.dwg
Project: NY 2306, 2306, Mercy College Athletic Field Improvements - 01 2436.dwg

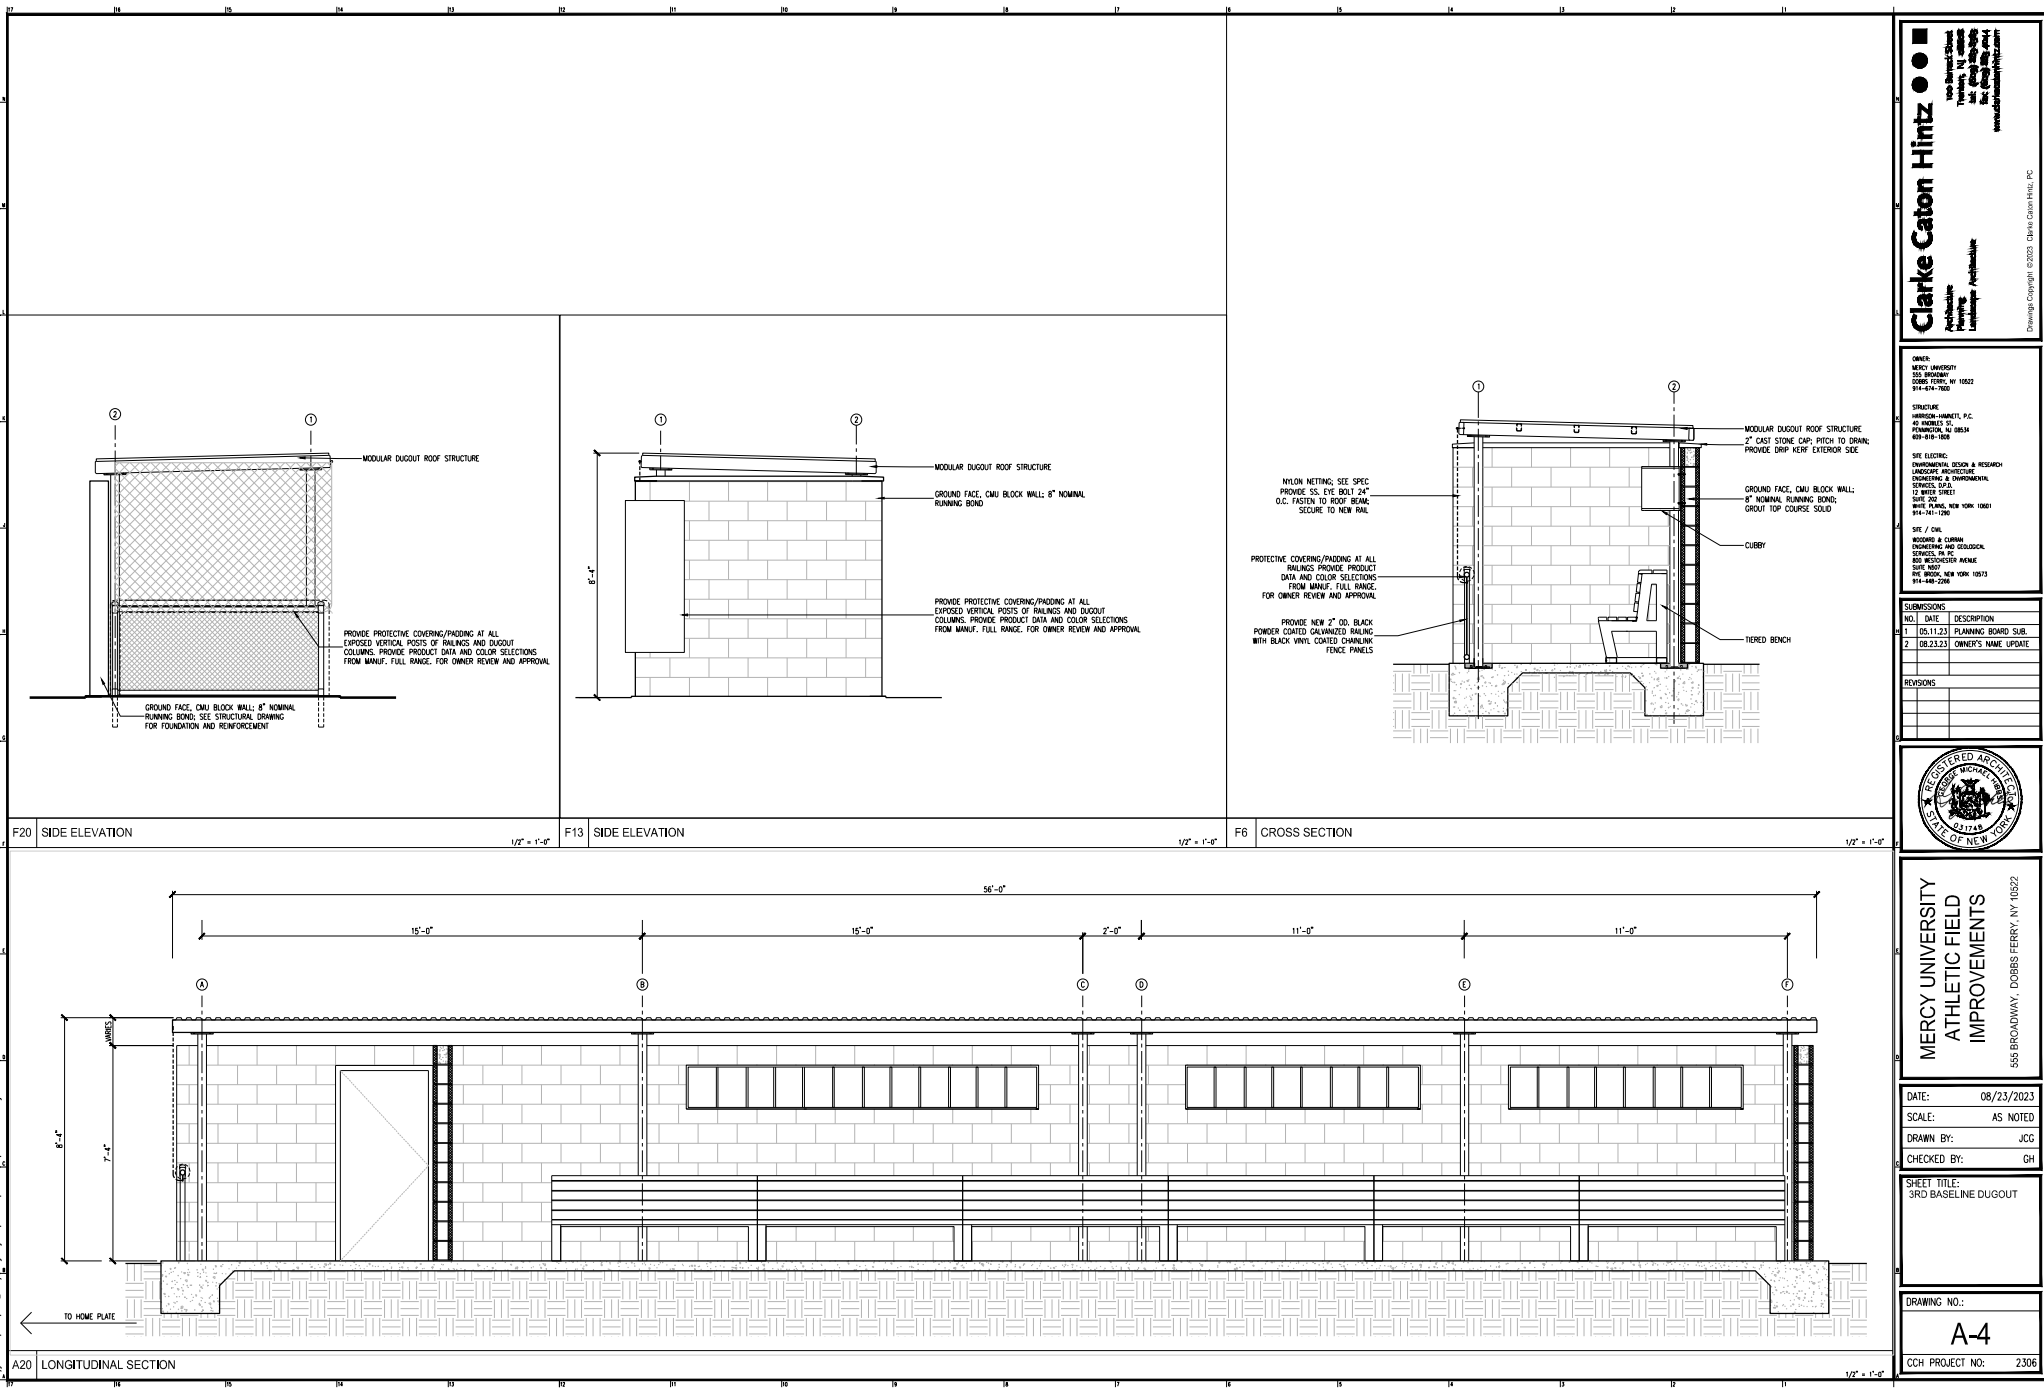

Clarke Caton Hintz

1000 Belmont Street
Trenton, NJ 08611
Tel: 609-392-1234
Fax: 609-392-1235
www.clarkecatonhintz.com

Architecture
Engineering
Landscape Architecture

Drawing Copyright ©2023, Clarke Caton Hintz, PC

OWNER:
MERCY UNIVERSITY
155 BROADWAY
DOBBS FERRY, NY 10522
914-480-1201

STRUCTURE:
HARRISON-HANDELL, P.C.
45 MONROE ST.
PERMANTON, NJ 08854
609-678-1000

SITE ELECTRIC:
ENVIRONMENTAL DESIGN & RESEARCH
LANDSCAPE ARCHITECTURE
ENGINEERING & ENVIRONMENTAL
SERVICES, LLC
12 WYER STREET
SUITE 200
MILLS PLAZA, NEW YORK, NY 10517
914-741-1206

SITE / CIVIL:
BOGARD & CURRAN
ENGINEERING AND GEOSURVEYING
3140 NEW YORK AVENUE
SUITE 100
DOVER, NJ 07801
973-261-1200

SUBMISSIONS		
NO.	DATE	DESCRIPTION
1	08.11.23	PLANNING BOARD SUB.
2	08.23.23	OWNER'S NAME UPDATE

REVISIONS		
NO.	DATE	DESCRIPTION



**MERCY UNIVERSITY
ATHLETIC FIELD
IMPROVEMENTS**

555 BROADWAY, DOBBS FERRY, NY 10522


DATE: 08/23/2023
SCALE: AS NOTED
DRAWN BY: JCC
CHECKED BY: GH

SHEET TITLE:
SRD BASELINE DUGOUT


DRAWING NO.:
A-4

CCH PROJECT NO.: 2306

1233492306.dwg
Project: N:\2306\2306_MercyCollege\Drawings\2-Improvements\A-01_A436.dwg

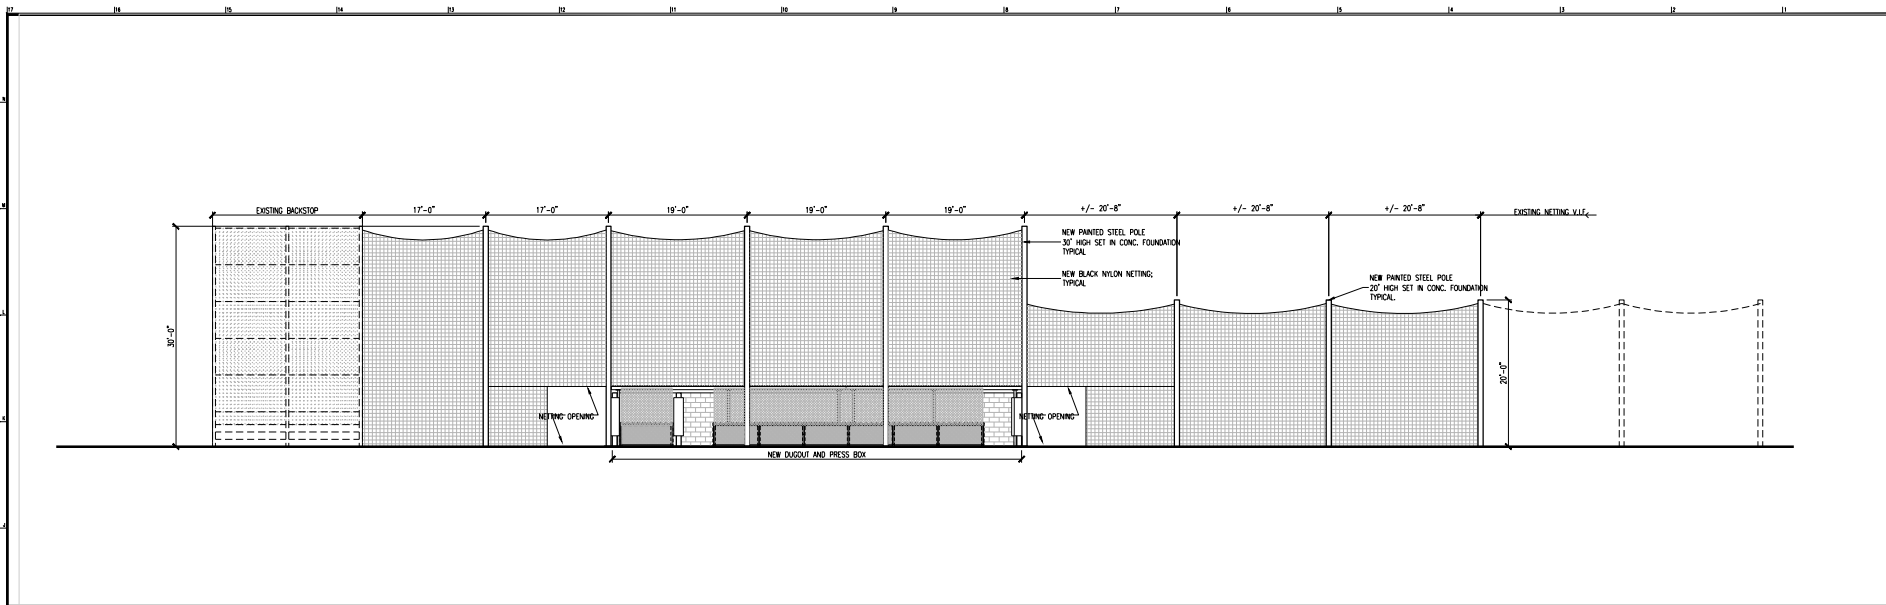

K20 DUGOUT AND NETTING/POLE ELEVATION - 3RD BASE LINE

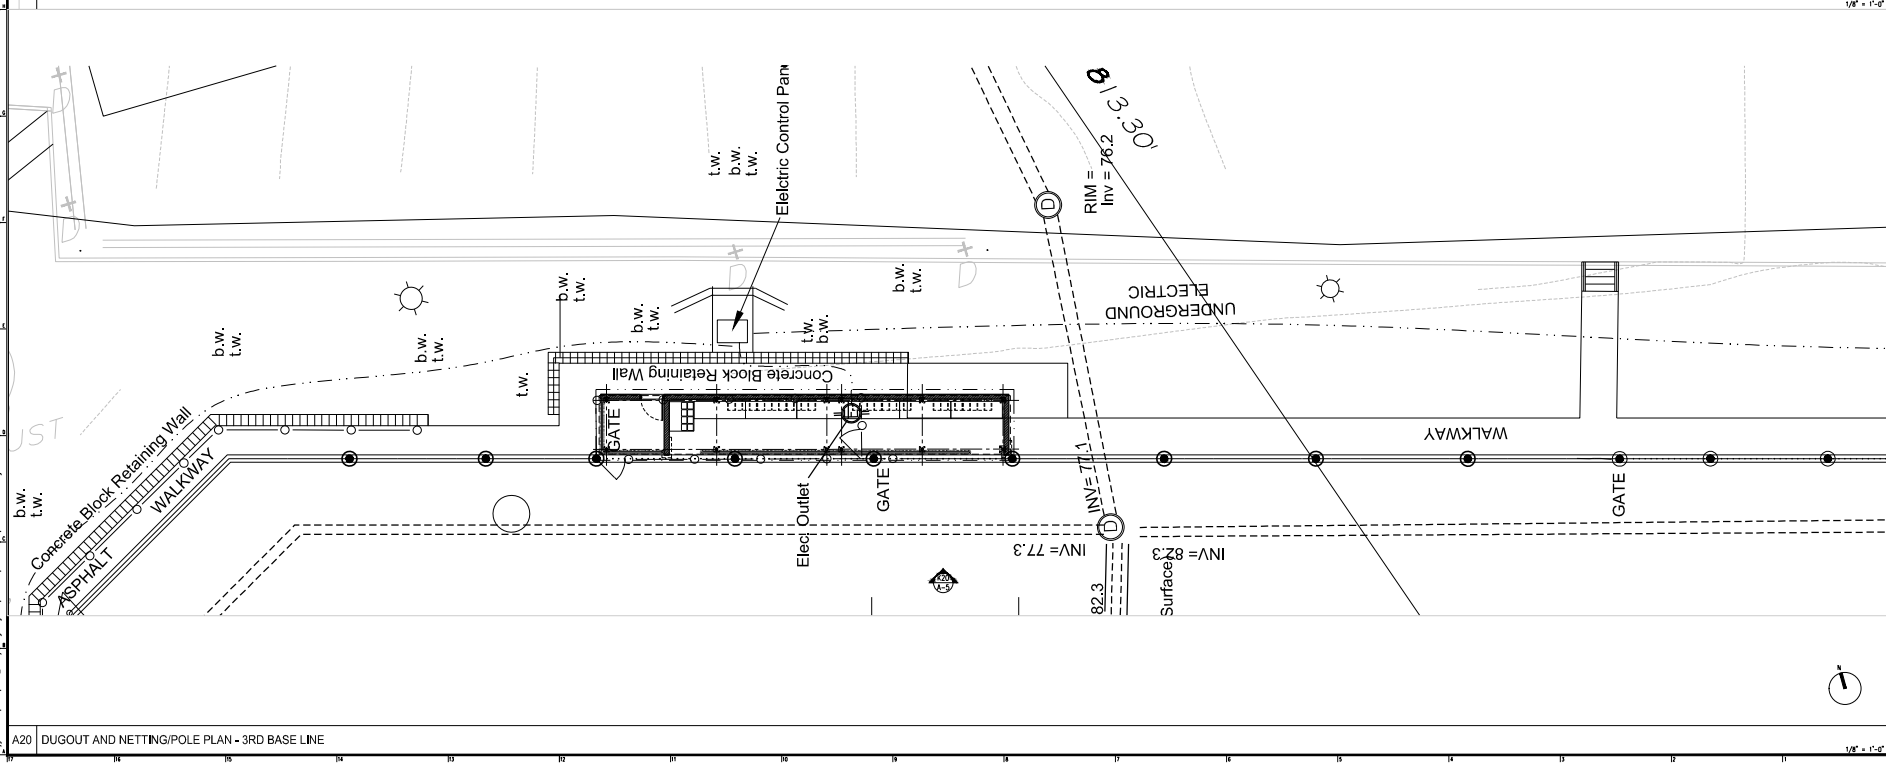

A20 DUGOUT AND NETTING/POLE PLAN - 3RD BASE LINE

Clarke Caton Hintz

1000 Stewart Street
Trenton, NJ 08611
609-689-1000
www.clarkecatonhintz.com

OWNER:
MERCY UNIVERSITY
155 BROADWAY
DOBBS FERRY, NY 10522
914-489-1000

STRUCTURE:
HARRISON-HANDEL, P.C.
45 PARKER ST.
PENNSAULT, NJ 08854
609-689-1000

SITE / ELEC:
ENVIRONMENTAL DESIGN & RESEARCH
LANDSCAPE ARCHITECTURE
ENGINEERING & ENVIRONMENTAL
SERVICES, LLC
12 BREYER STREET
SUITE 200
BRIDGE PLANK, NEW YORK, NY 10521
914-741-1200

SITE / CIVIL:
BOOKING & CURRIN
ENGINEERING AND GEOTECHNICAL
SERVICES, P.C.
805 RECOVERER AVENUE
SUITE 100
PINE BROOK, NEW YORK 10573
914-489-1000

SUBMISSIONS:

NO.	DATE	DESCRIPTION
1	08.11.23	PLANNING BOARD SUB.
2	08.23.23	OWNER'S NAME UPDATE

REVISIONS:

NO.	DATE	DESCRIPTION

REGISTERED ARCHITECT
STATE OF NEW YORK
021748

**MERCY UNIVERSITY
ATHLETIC FIELD
IMPROVEMENTS**
555 BROADWAY, DOBBS FERRY, NY 10522

DATE: 08/23/2023
SCALE: AS NOTED
DRAWN BY: JCC
CHECKED BY: GH


SHEET TITLE:
NETTING ELEVATION AND LAYOUT

DRAWING NO.:
A-5

CCH PROJECT NO.: 2306


Drawing Copyright ©2023, Clarke Caton Hintz, P.C.

12378923456789
Project: N:\2306\2306_MercyAthleticField\2-0805\2-0805.dwg
Date: 08/23/2023

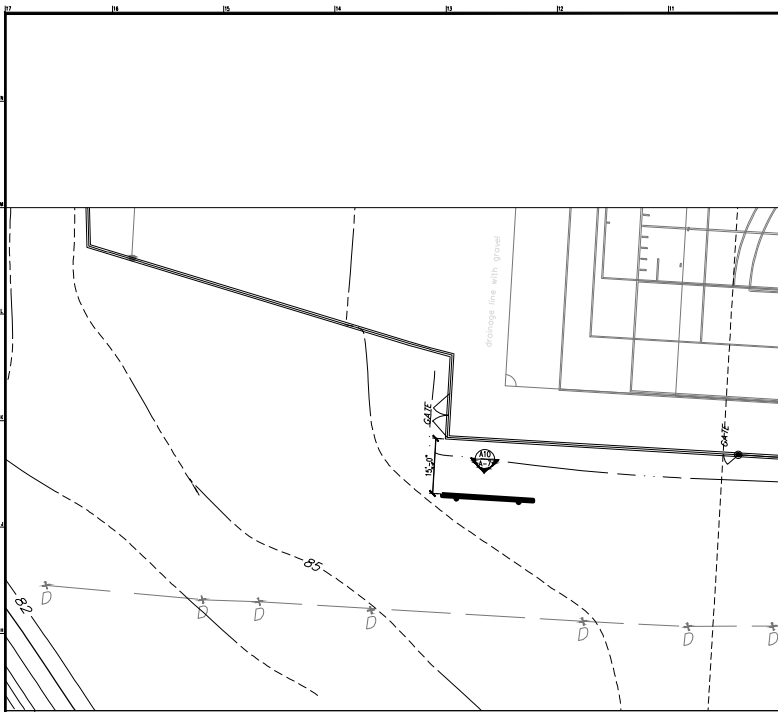


G17 SCOREBOARD LOCATION PLAN

1/8" = 1'-0"

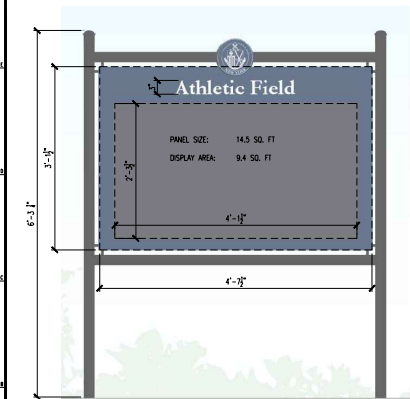


M14 DIGITAL SIGN ELEVATION

1" = 1'-0"

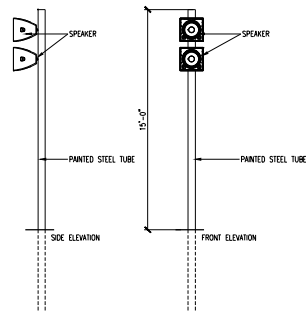

A20 POLE MOUNTED SPEAKER ELEVATION

1/8" = 1'-0"

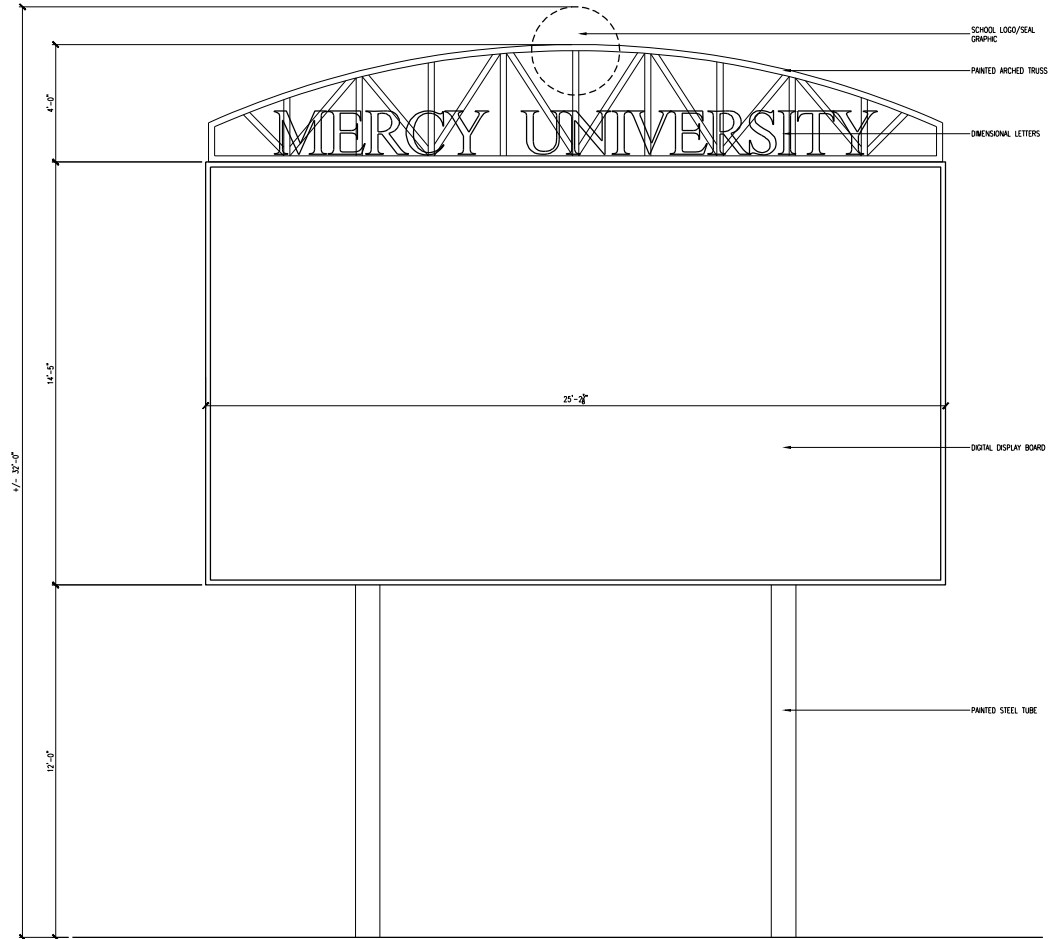

A10 SCOREBOARD ELEVATION

1/2" = 1'-0"

Clarke Caton Hintz
 Architects
 1000 West 10th Street
 Suite 100
 Des Moines, IA 50319
 Phone: 515.281.1111
 Fax: 515.281.1112
 www.clarkecatonhintz.com

OWNER:
 MERCY UNIVERSITY
 155 BROADWAY
 DOBBS FERRY, NY 10522
 914-480-1000

STRUCTURE:
 HARRISON-HANDELL, P.C.
 40 PARKER ST.
 PENNSACOLA, FL 32504
 904-878-1000

SITE ELECTRIC:
 ENVIRONMENTAL DESIGN & RESEARCH
 LANDSCAPE ARCHITECTURE
 ENGINEERING & ENVIRONMENTAL
 SERVICES, LLC
 12 WEST STREET
 SUITE 200
 BRIDGE PLAZA, NEW YORK, NY 10012
 914-741-1200

SITE / CIVIL:
 BOONING & CURRAN
 ENGINEERING AND DESIGN, LLC
 805 RECOVERER AVENUE
 SUITE 100
 PINE BROOK, NEW YORK 10573
 914-480-2000

SUBMISSIONS	
NO.	DESCRIPTION
1	08.11.23 PLANNING BOARD SUB.
2	08.23.23 OWNER'S NAME UPDATE



**MERCY UNIVERSITY
 ATHLETIC FIELD
 IMPROVEMENTS**
 555 BROADWAY, DOBBS FERRY, NY 10522

DATE: 08/23/2023
 SCALE: AS NOTED
 DRAWN BY: JCC
 CHECKED BY: GH

SHEET TITLE:
 SCOREBOARD ELEVATION,
 POLE MOUNTED SPEAKER
 DETAIL AND SIGN PANEL

DRAWING NO.:

A-7
 CCH PROJECT NO.: 2306

1233490230301
 Project: N:\2306\2306_MercyCollege\Drawings\2-Improvements\A-7-Signage\A-01_A7A3.dwg